

SPECIFICATIONS

FINISHES
 PL-1: PLASTIC LAMINATE, FENIX, BLU FES J0754, MATTE FINISCH
 PL-2: PLASTIC LAMINATE, BELLA LAMINATI, OREGON LEAF WOOD PW-6602, MULTI RIGHE
 WD-1: STAINED WOOD WALNUT TO MATCH SURFACING TAMBOR WALL PANELS SKU-383
 S-1: MANMADE QUARTZ SLABS, DEKTON, TRANCE ONIRIKA, POLISHED FINISH
 WM: WHITE MELAMINE

HARDWARE
HINGES: CONCEALED SELF CLOSING
SLIDING TRACKS: ACCURIDE MEDIUM DUTY FULL EXTENSION, SIDE MOUNTED
PULLS: TBD

APPLIANCE & EXCLUSIONS
APPLIANCES BY OTHERS
PLUMBING FIXTURES BY OTHERS
STONE BY OTHERS

APPROVED/NO CHANGES
 APPROVED/AS NOTED
 REVISE AS NOTED/RESUBMIT
 SIGNATURE _____ DATE _____

REVISIONS

Nr	DATE	DESCRIPTION	BY	OBS.

ONCE APPROVED, THIS DRAWING SUPERSEDES ALL PREVIOUS ARCHITECTURAL & SHOP DRAWINGS
 APPROVED BY:
 SIGNATURE _____ DATE _____


ABBREVIATIONS

AFF=Above Fin Floor	FE=Finished End
BSE=Base	FF=Face Frame
BOX=Back	FO=Finished Opening
CABT=Cabinet	FP=Fixed Panel
CAS=Casing	FD=Door Dimension
CL=Clear Opening	OU=Outer Dimension
CTOP=Counter Top	PNL=Panel
DB=Drawer Box	RO=Rough Opening
DF=Drawer Face	POI=Pull Out Tray
WF=Verify In Field	RM=Removable Panel
DI=Field Dimension	SIF=Adj. Shelf

PROJECT: _____
 WOODWORK, INC.

DRAWING TITLE: **Pantry 117**
 DWN BY: _____ SCALE: _____ DWG NO.: _____
 DATE: 11/07/20 AS NOTED S1.1

1 TOP VIEW
 Scale: 1/2"=1'

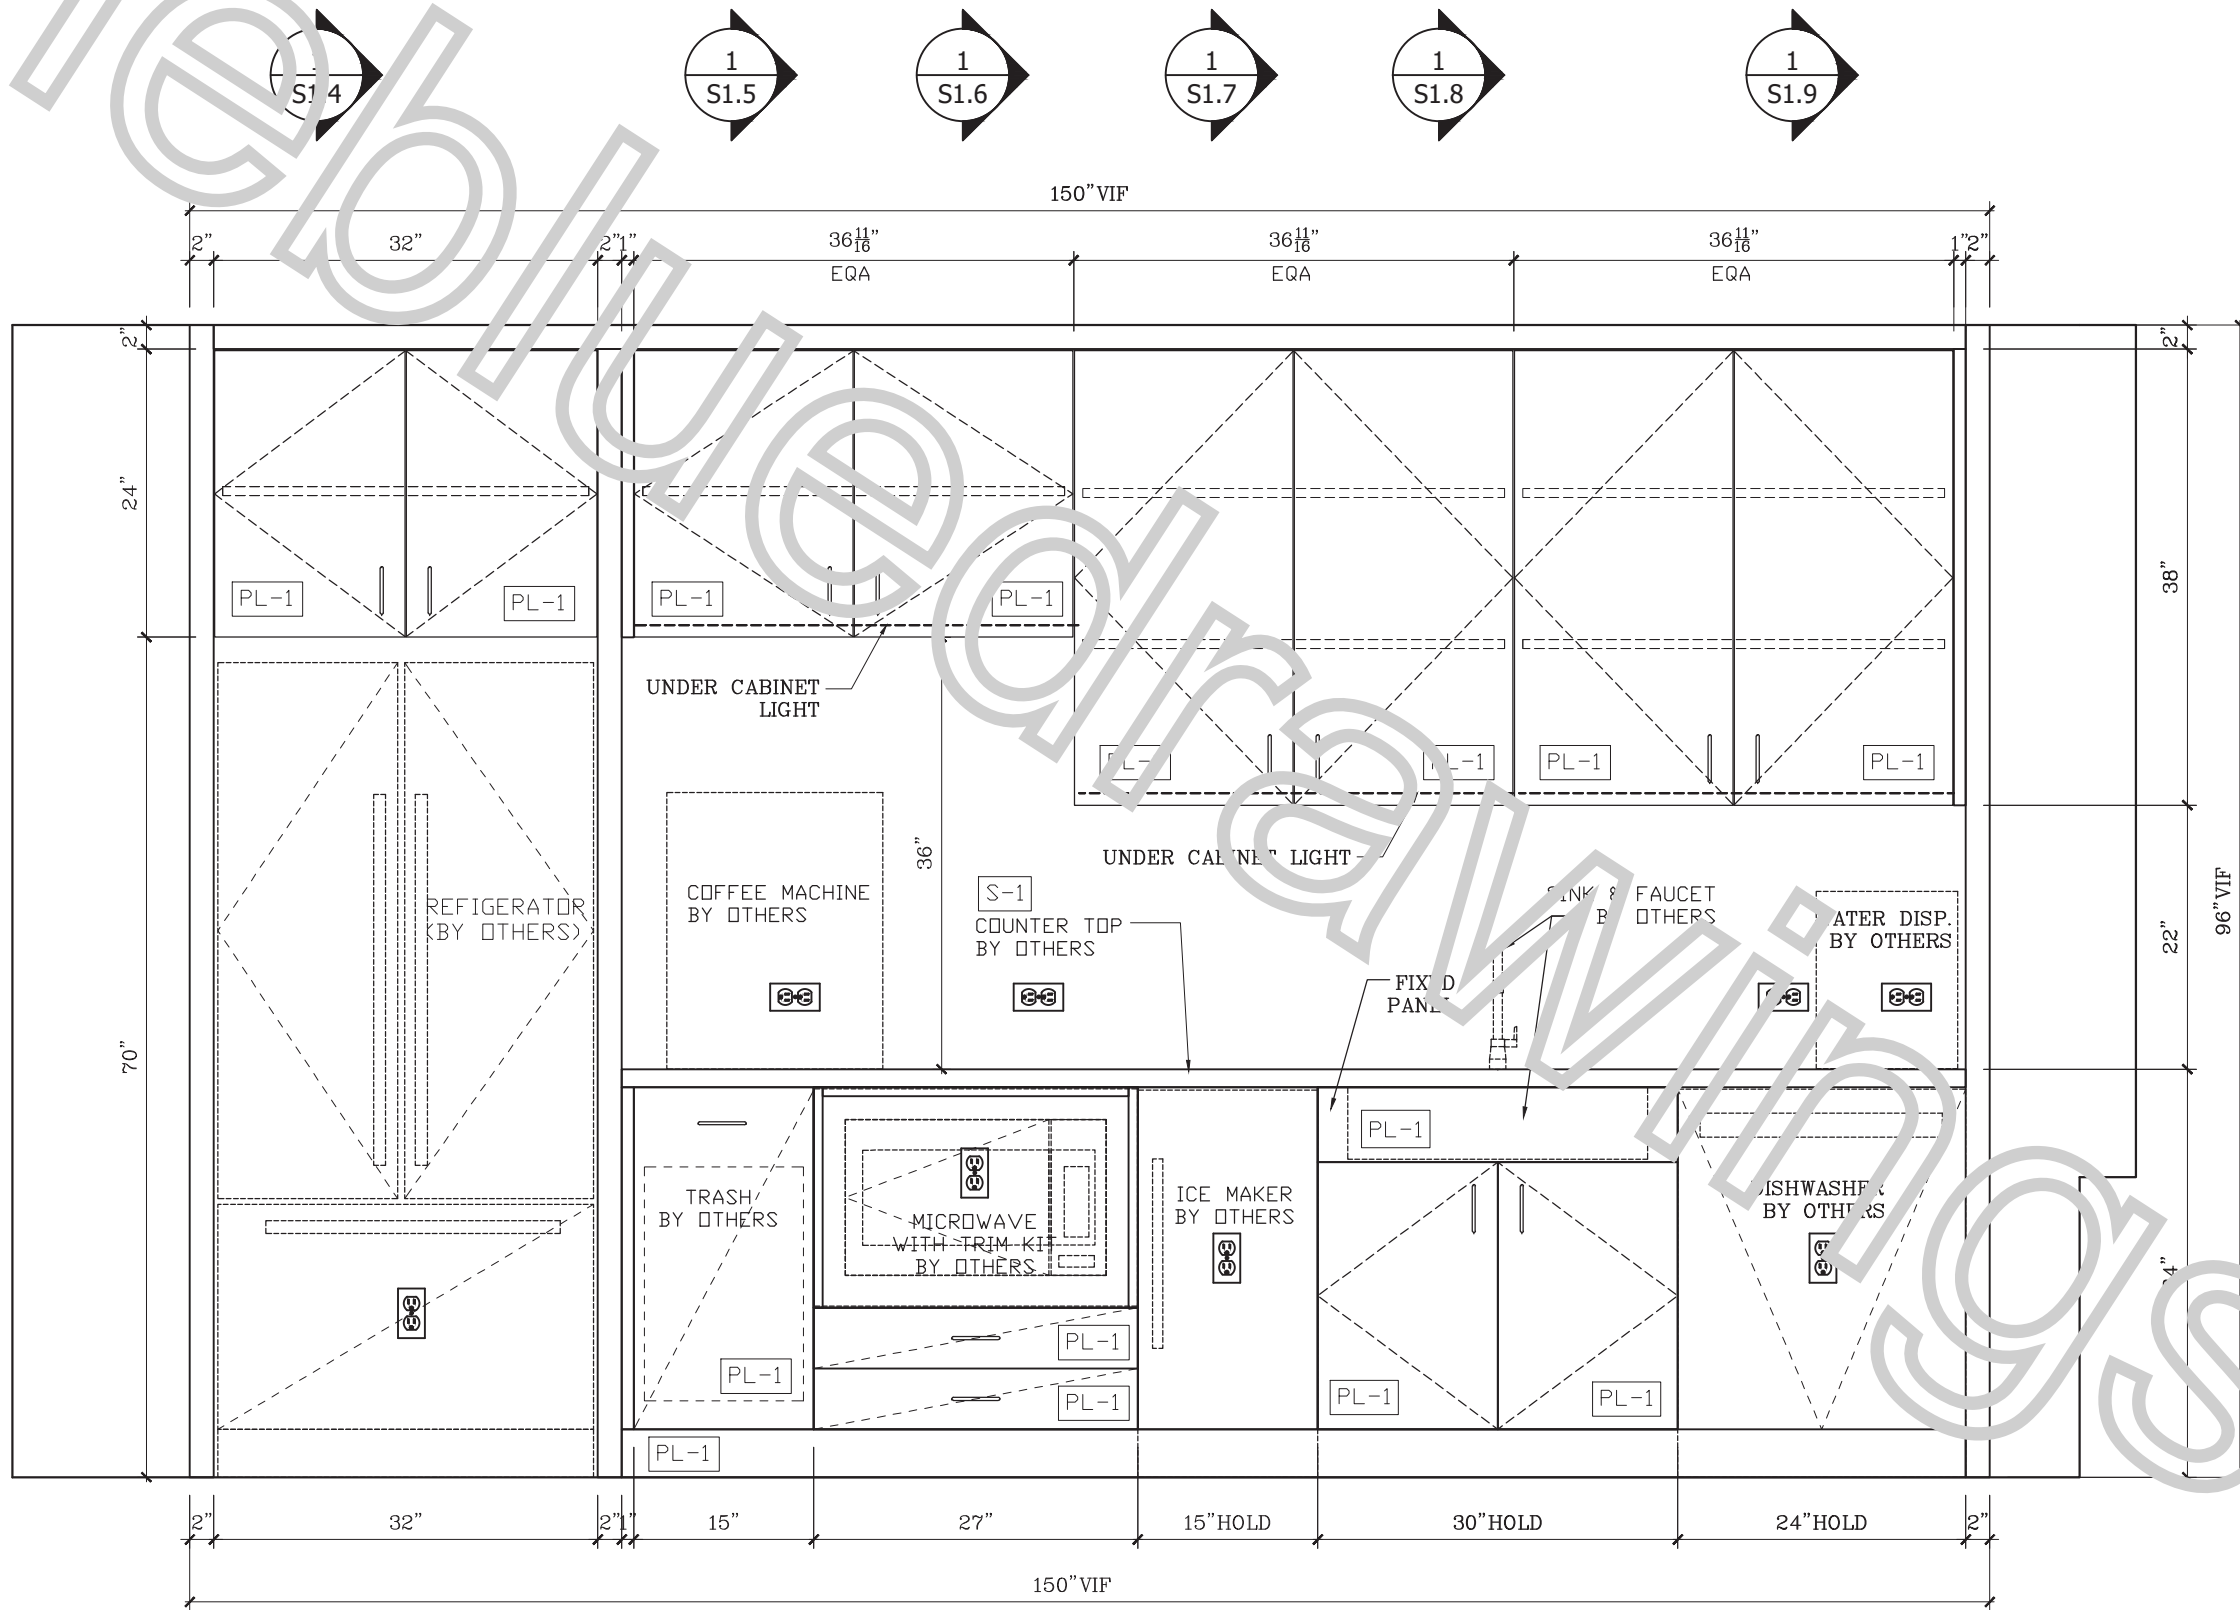

1 ELEVATION
Scale: 3/4"=1'

SPECIFICATIONS

FINISHES
 PL-1: PLASTIC LAMINATE, FENIX, BLU FES J0754, MATTE FINISCH
 PL-2: PLASTIC LAMINATE, BELLA LAMINATI, OREGON LEAF WOOD PW-6602, MULTI RIGHE
 WD-1: STAINED WOOD WALNUT TO MATCH SURFACING TAMBOR WALL PANELS SKU-383
 S-1: MANMADE QUARTZ SLABS, DEKTON, TRANCE ONIRIKA, POLISHED FINISH
 WM: WHITE MELAMINE

HARDWARE
HINGES: CONCEALED SELF CLOSING
SLIDING TRACKS: ACCURIDE MEDIUM DUTY FULL EXTENSION, SIDE MOUNTED
PULLS: TBD

APPLIANCE & EXCLUSIONS
APPLIANCES BY OTHERS
PLUMBING FIXTURES BY OTHERS
STONE BY OTHERS

APPROVED/NO CHANGES
 APPROVED/AS NOTED
 REVISE AS NOTED/RESUBMIT
 SIGNATURE _____ DATE _____

REVISIONS

Nr	DATE	DESCRIPTION	BY	OBS.


ONCE APPROVED, THIS DRAWING SUPERSEDES ALL PREVIOUS ARCHITECTURAL & SHOP DRAWINGS
 APPROVED BY:
 SIGNATURE _____ DATE _____

ABBREVIATIONS

AFF=Above Fin Floor	FE=Finished End
BSE=Base	FF=Face Frame
BCK=Back	FO=Finished Opening
CAB=Cabinet	FP=Fixed Panel
CAS=Case	IF=Inner Dimension
CL=Clear Opening	OD=Outer Dimension
CTOP=Counter Top	PAL=Panel
DB=Drawer Box	RO=Rough Opening
DF=Drawer Face	PO=Pull Out Tray
WF=Verify in Field	RM=Removable Panel
FD=Field Dimension	SIF=Add Shelf

PROJECT:
 DRAWING TITLE:
 Panty 117

OWN BY:	SCALE:	DWG NO.:
DATE:	AS NOTED	01
11/07/2		

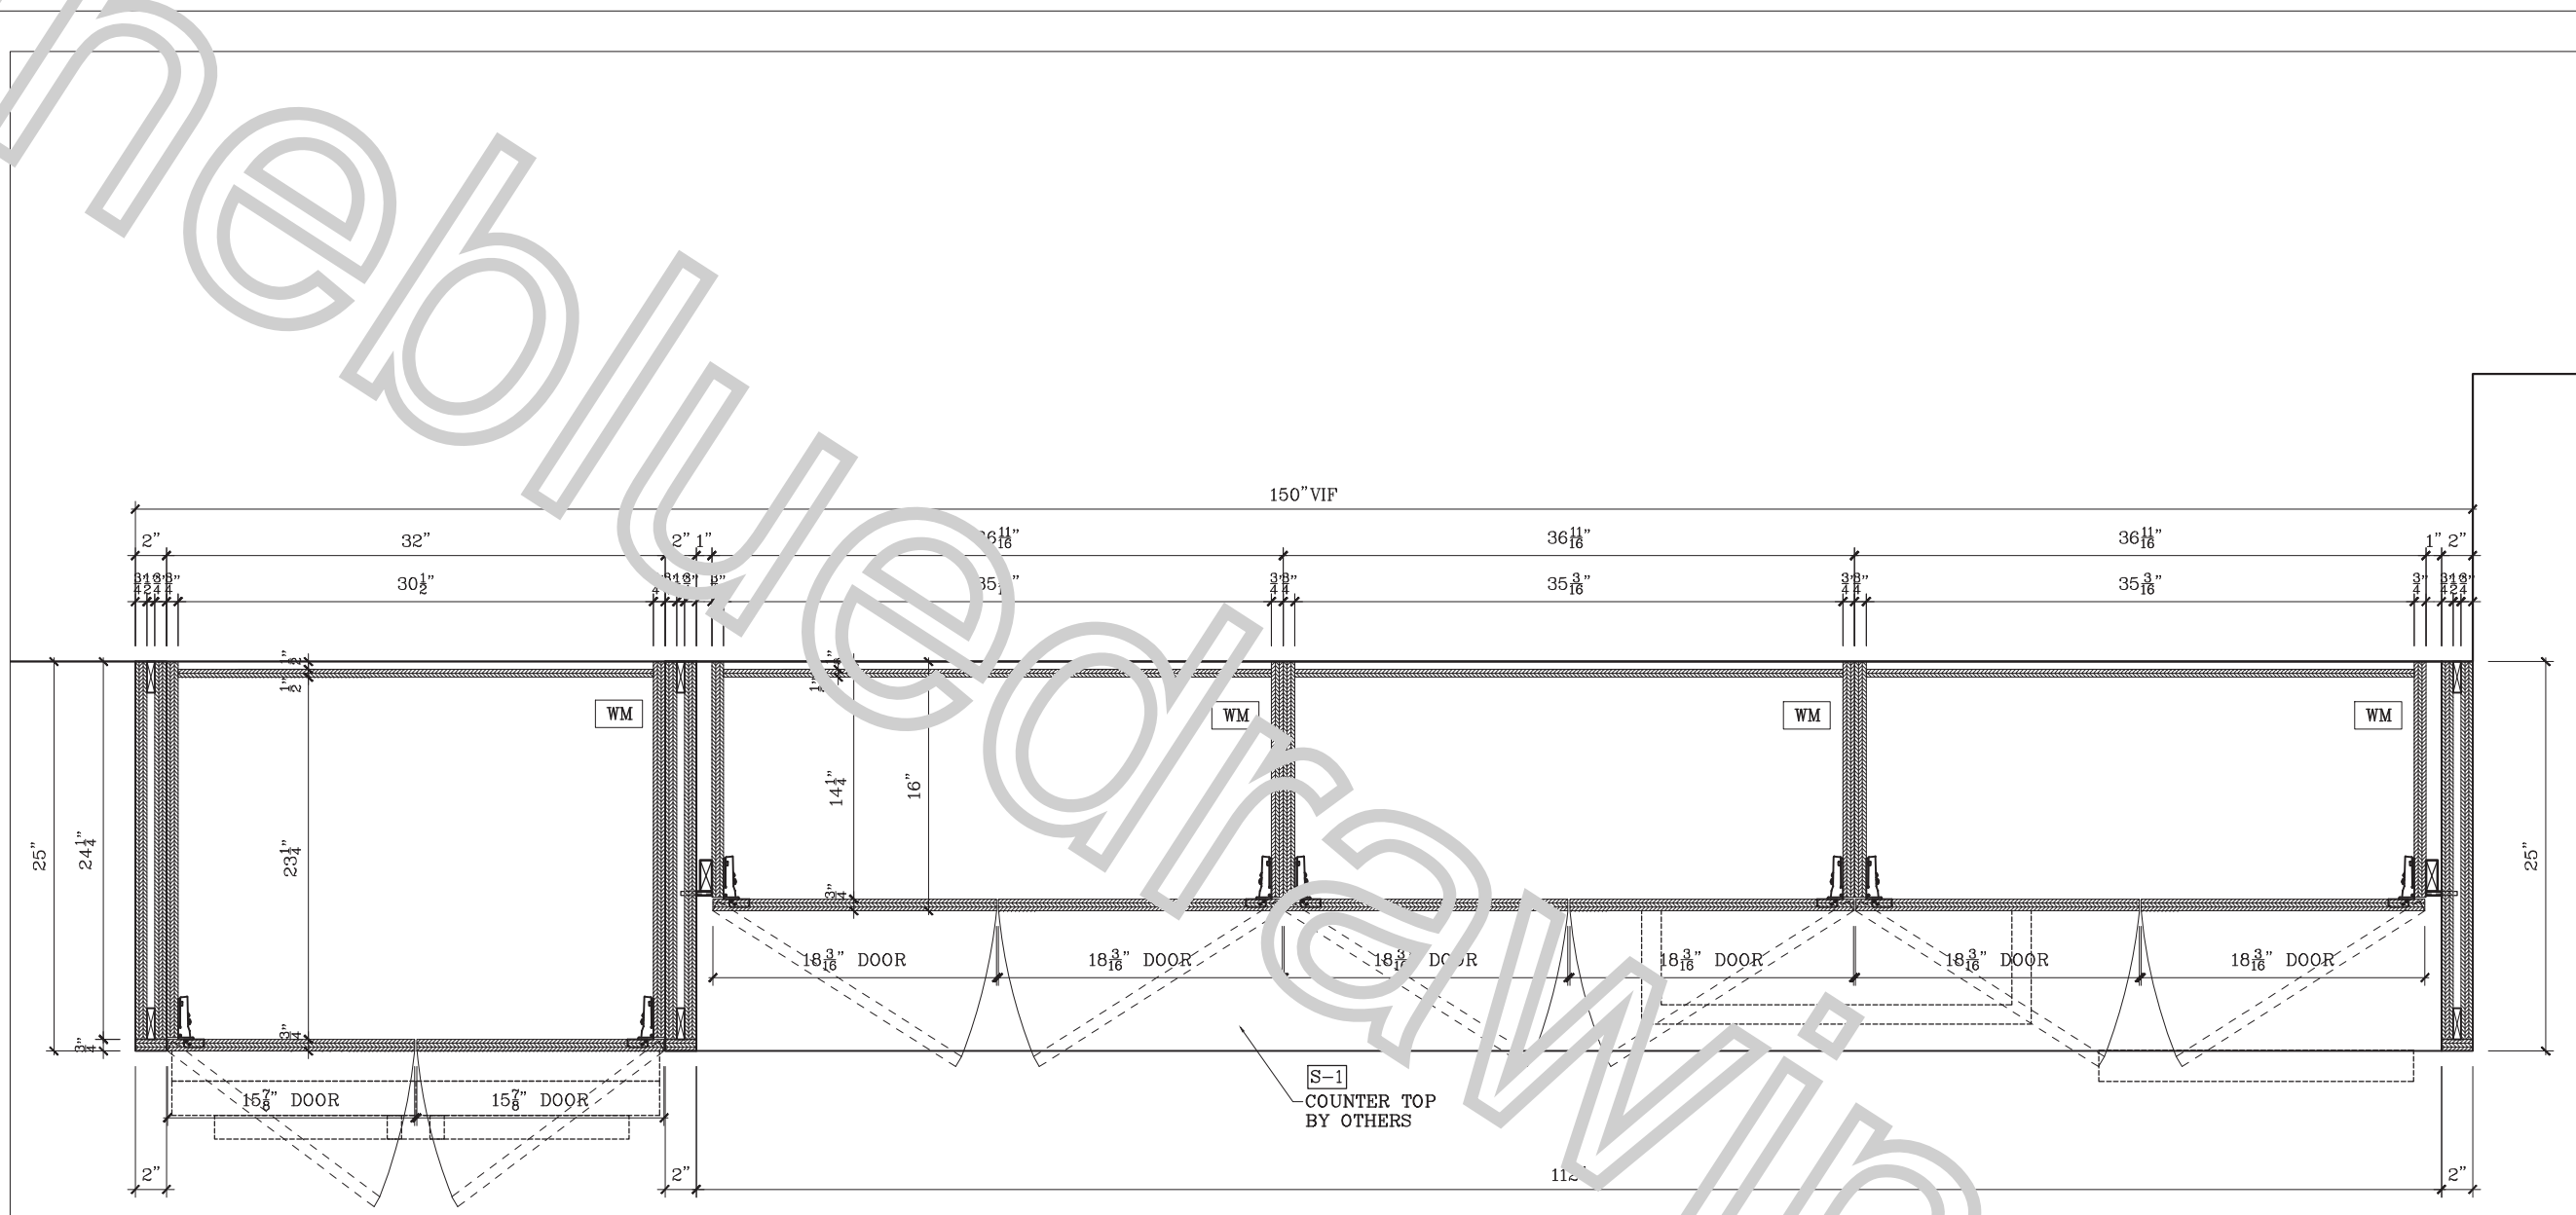

1 UPPER HORIZONTAL SECTION
Scale: 1"=1'

SPECIFICATIONS

FINISHES
 PL-1: PLASTIC LAMINATE, FENIX, BLU FES J0754, MATTE FINISCH
 PL-2: PLASTIC LAMINATE, BELLA LAMINATI, OREGON LEAF WOOD PW-6602, MULTI RIGHE
 WD-1: STAINED WOOD WALNUT TO MATCH SURFACING TAMBOR WALL PANELS SKU-383
 S-1: MANMADE QUARTZ SLABS, DEKTON, TRANCE ONIRIKA, POLISHED FINISH
 WM: WHITE MELAMINE

HARDWARE
 HINGES: CONCEALED SELF CLOSING
 SLIDING TRACKS: ACCURIDE MEDIUM DUTY FULL EXTENSION, SIDE MOUNTED
 PULLS: TBD

APPLIANCE & EXCLUSIONS
 APPLIANCES BY OTHERS
 PLUMBING FIXTURES BY OTHERS
 STONE BY OTHERS

APPROVED/NO CHANGES
 APPROVED/AS NOTED
 REVISE AS NOTED/RESUBMIT
 SIGNATURE _____ DATE _____

REVISIONS

Nr	DATE	DESCRIPTION	BY	OBS.


ONCE APPROVED, THIS DRAWING SUPERSEDES ALL PREVIOUS ARCHITECTURAL & SHOP DRAWINGS
 APPROVED BY:
 SIGNATURE _____ DATE _____

ABBREVIATIONS


AFF=Above Fin Floor	FE=Finished End
BSE=Base	FF=Face Frame
BCK=Back	FO=Finished Opening
CABT=Cabinet	FP=Fixed Panel
CAS=Casing	IS=Inner Dimension
CL=Clear Opening	OJ=Outer Dimension
CTOP=Counter Top	PAL=Panel
DE=Drawer Box	RO=Rough Opening
DF=Drawer Face	POI=Pull Out Tray
WF=Verify in Field	REM=Removable Panel
FD=Field Dimension	SIF=Adj. Shelf

PROJECT:
 DA [Redacted]
 AR [Redacted]
 CO [Redacted]
 IN [Redacted]
 VI [Redacted]

DRAWING TITLE:
 Pantry 17
 DWN BY: [Redacted] SCALE: AS NOTED DWG NO.: [Redacted]
 DATE: 11/07/20 [Redacted]

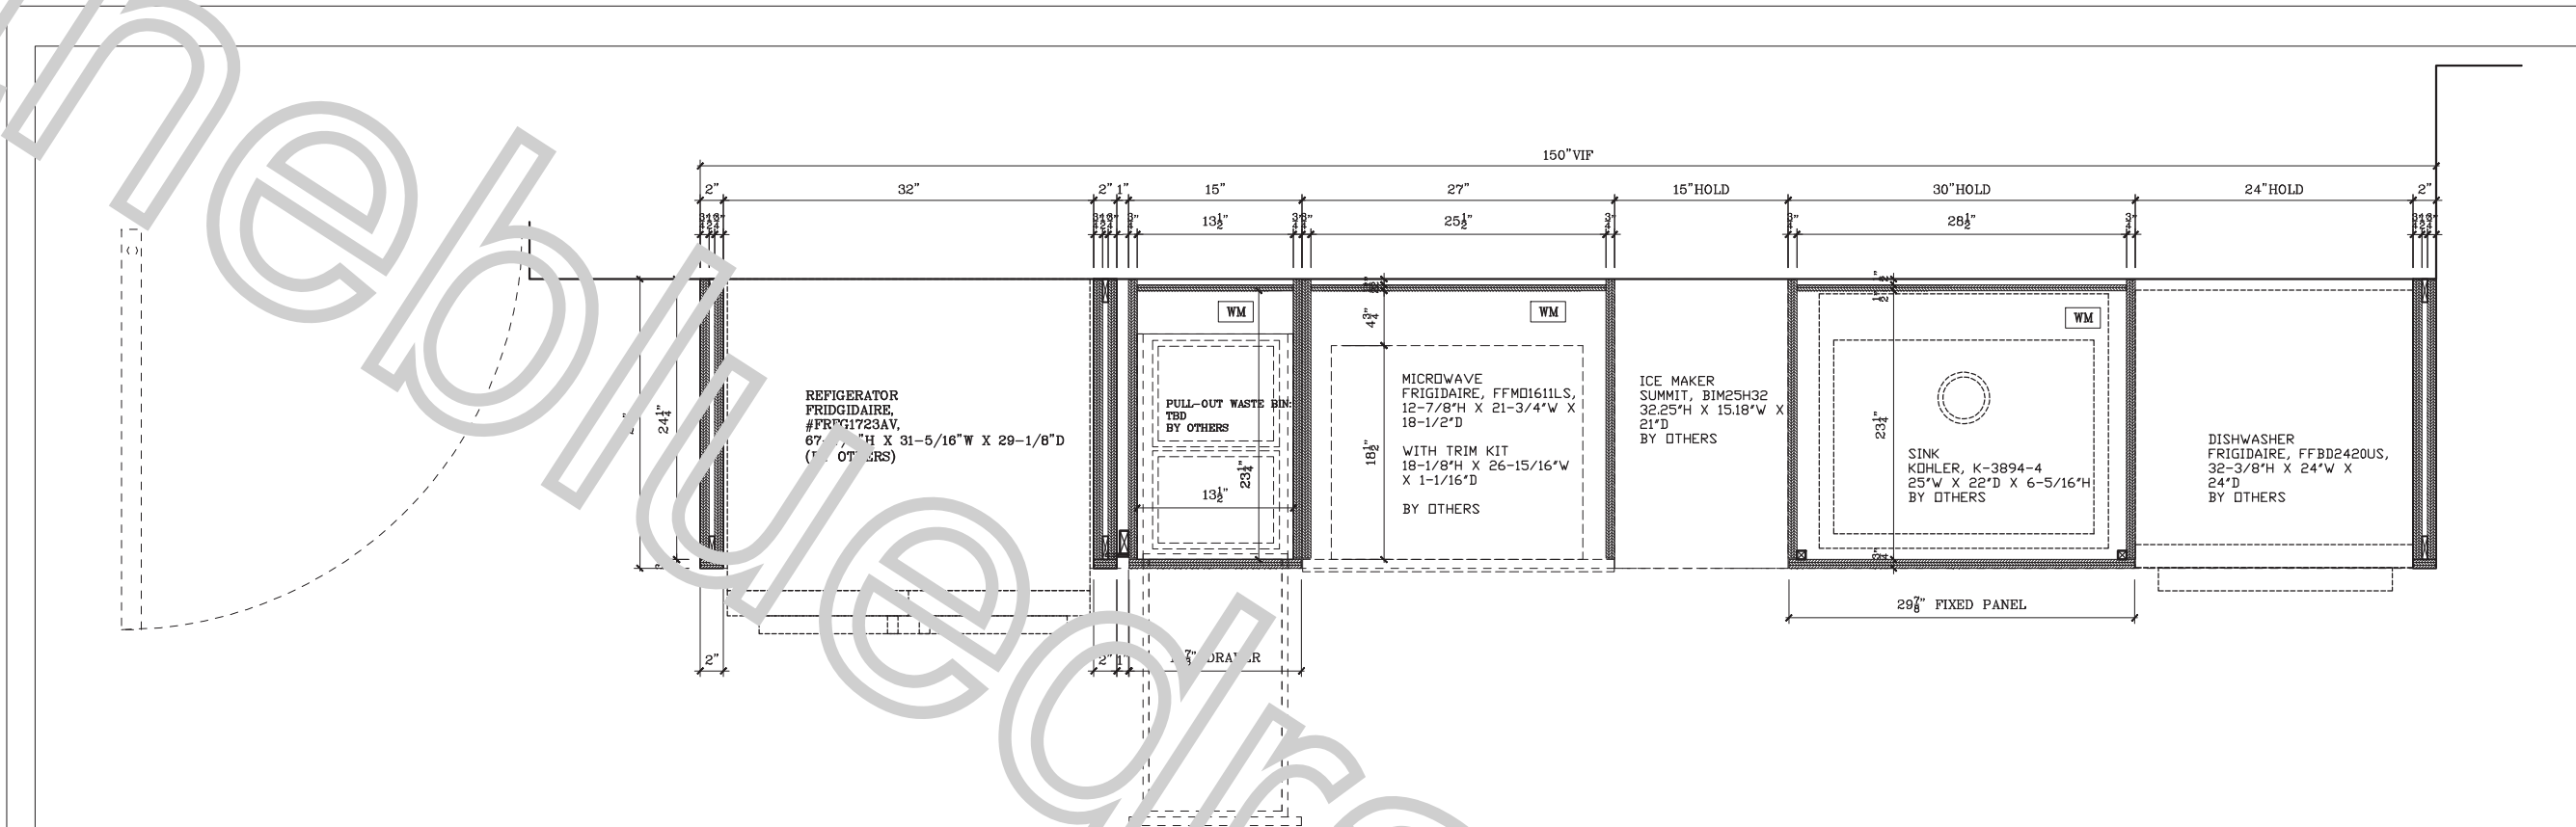

1 HORIZONTAL SECTION
Scale: 3/4"=1'

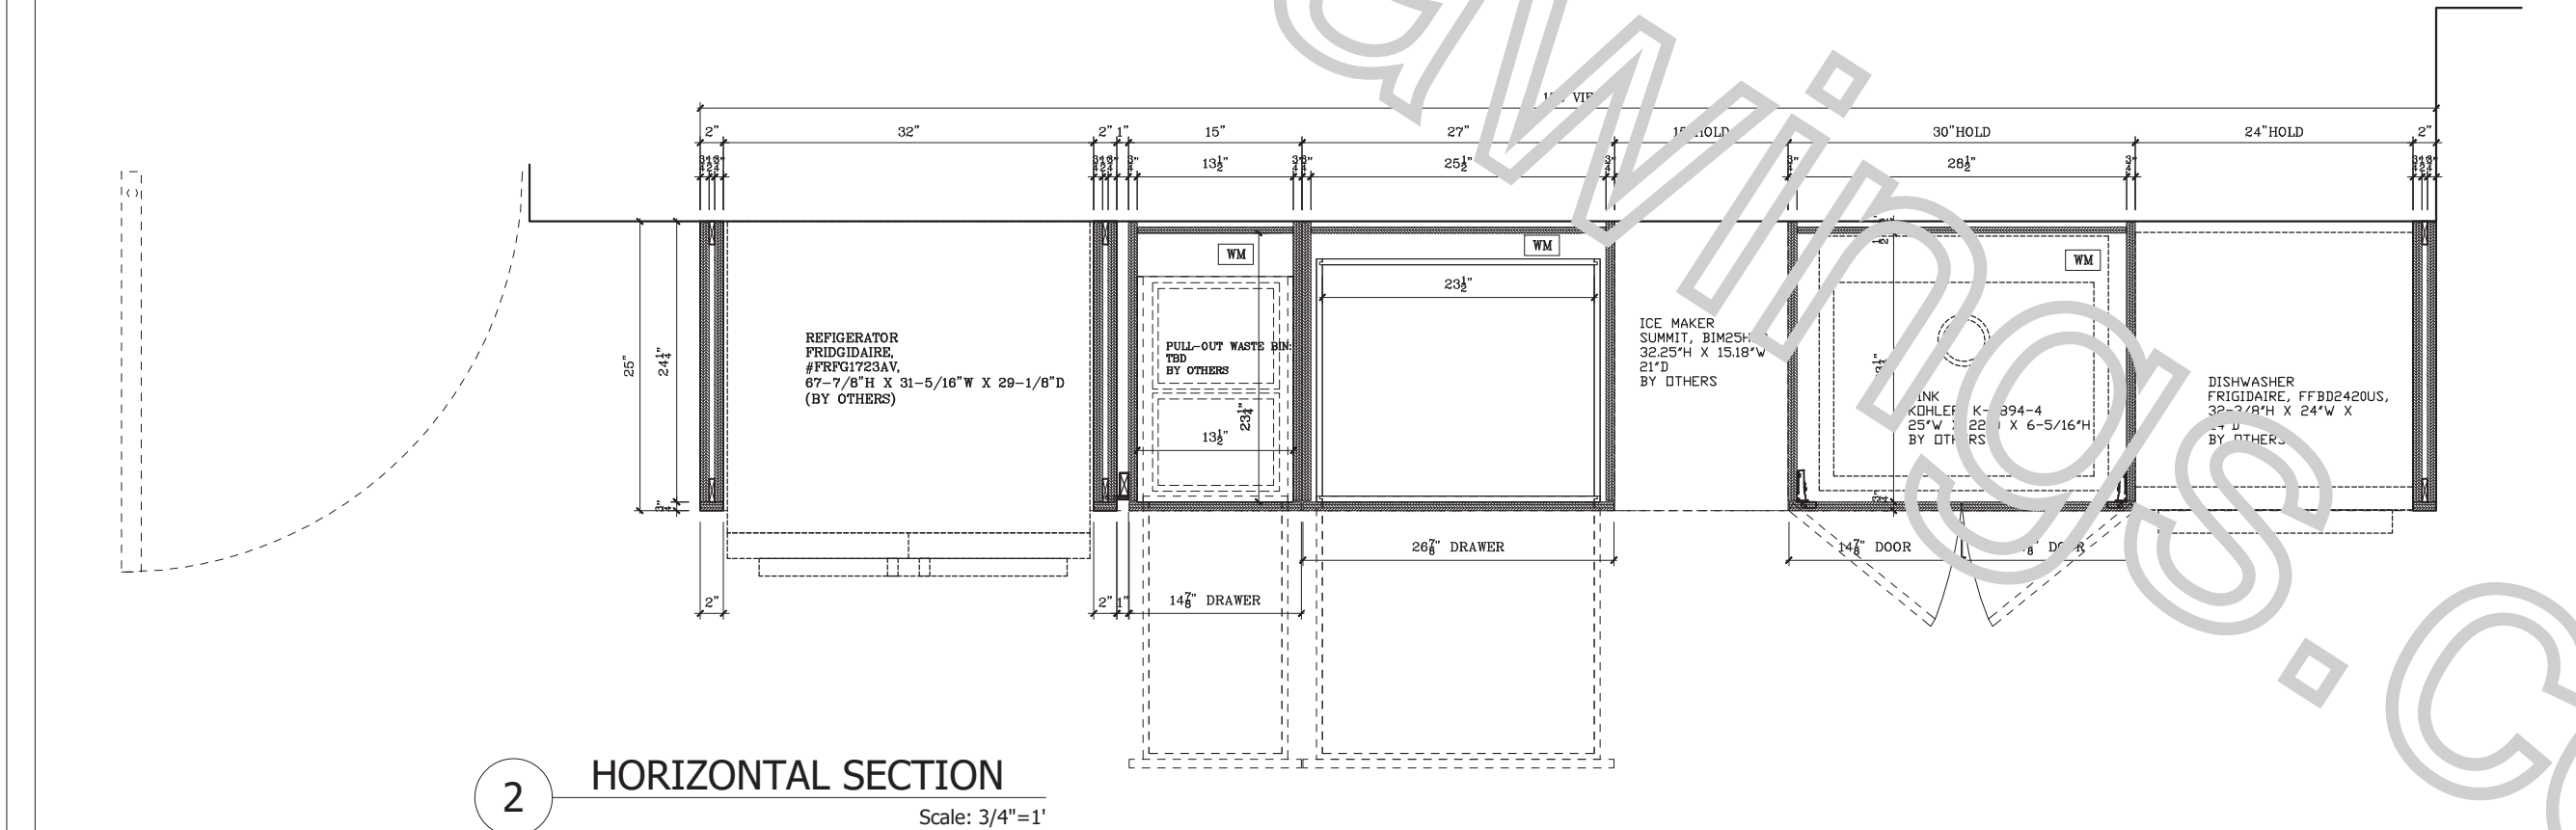

2 HORIZONTAL SECTION
Scale: 3/4"=1'

SPECIFICATIONS

FINISHES
 PL-1: PLASTIC LAMINATE, FENIX, BLU FES J0754, MATTE FINISCH
 PL-2: PLASTIC LAMINATE, BELLA LAMINATI, OREGON LEAF WOOD PW-6602, MULTI RIGHE
 WD-1: STAINED WOOD WALNUT TO MATCH SURFACING TAMBOR WALL PANELS SKU-383

S-1: MANMADE QUARTZ SLABS, DEKTON, TRANCE ONIRIKA, POLISHED FINISH

WM: WHITE MELAMINE

HARDWARE
HINGES: CONCEALED SELF CLOSING
SLIDING TRACKS: ACCURIDE MEDIUM DUTY FULL EXTENSION, SIDE MOUNTED
PULLS: TBD

APPLIANCE & EXCLUSIONS
APPLIANCES BY OTHERS
PLUMBING FIXTURES BY OTHERS
STONE BY OTHERS

APPROVED/NO CHANGES
 APPROVED/AS NOTED
 REVISE AS NOTED/RESUBMIT

SIGNATURE _____ DATE _____

REVISIONS

Nr	DATE	DESCRIPTION	BY	OBS.

ONCE APPROVED, THIS DRAWING SUPERSEDES ALL PREVIOUS ARCHITECTURAL & SHOP DRAWINGS

APPROVED BY: _____

SIGNATURE _____ DATE _____

ABBREVIATIONS

AFF=Above Fin Floor	FE=Finished End
BSE=Base	FF=Face Frame
BCK=Back	FO=Finished Opening
CAB=Cabinet	FP=Fixed Panel
CAS=Case	FD=Face Dimension
CO=Clear Opening	OD=Outer Dimension
CTOP=Counter Top	PNL=Panel
DB=Drawer Box	RO=Rough Opening
DF=Drawer Face	PO=Pull Out Tray
WF=Verify in Field	RM=Removable Panel
DI=Field Dimension	SIF=Add Shelf

WOODWORK, INC.


DRAWING TITLE: _____

Pantry 17

OWN BY: _____ SCALE: _____ DWG NO.: _____
 AS NOTED

DATE: 11/07/20 _____

1 VERTICAL HORIZONTAL SECTION
Scale: 1-1/2"=1'

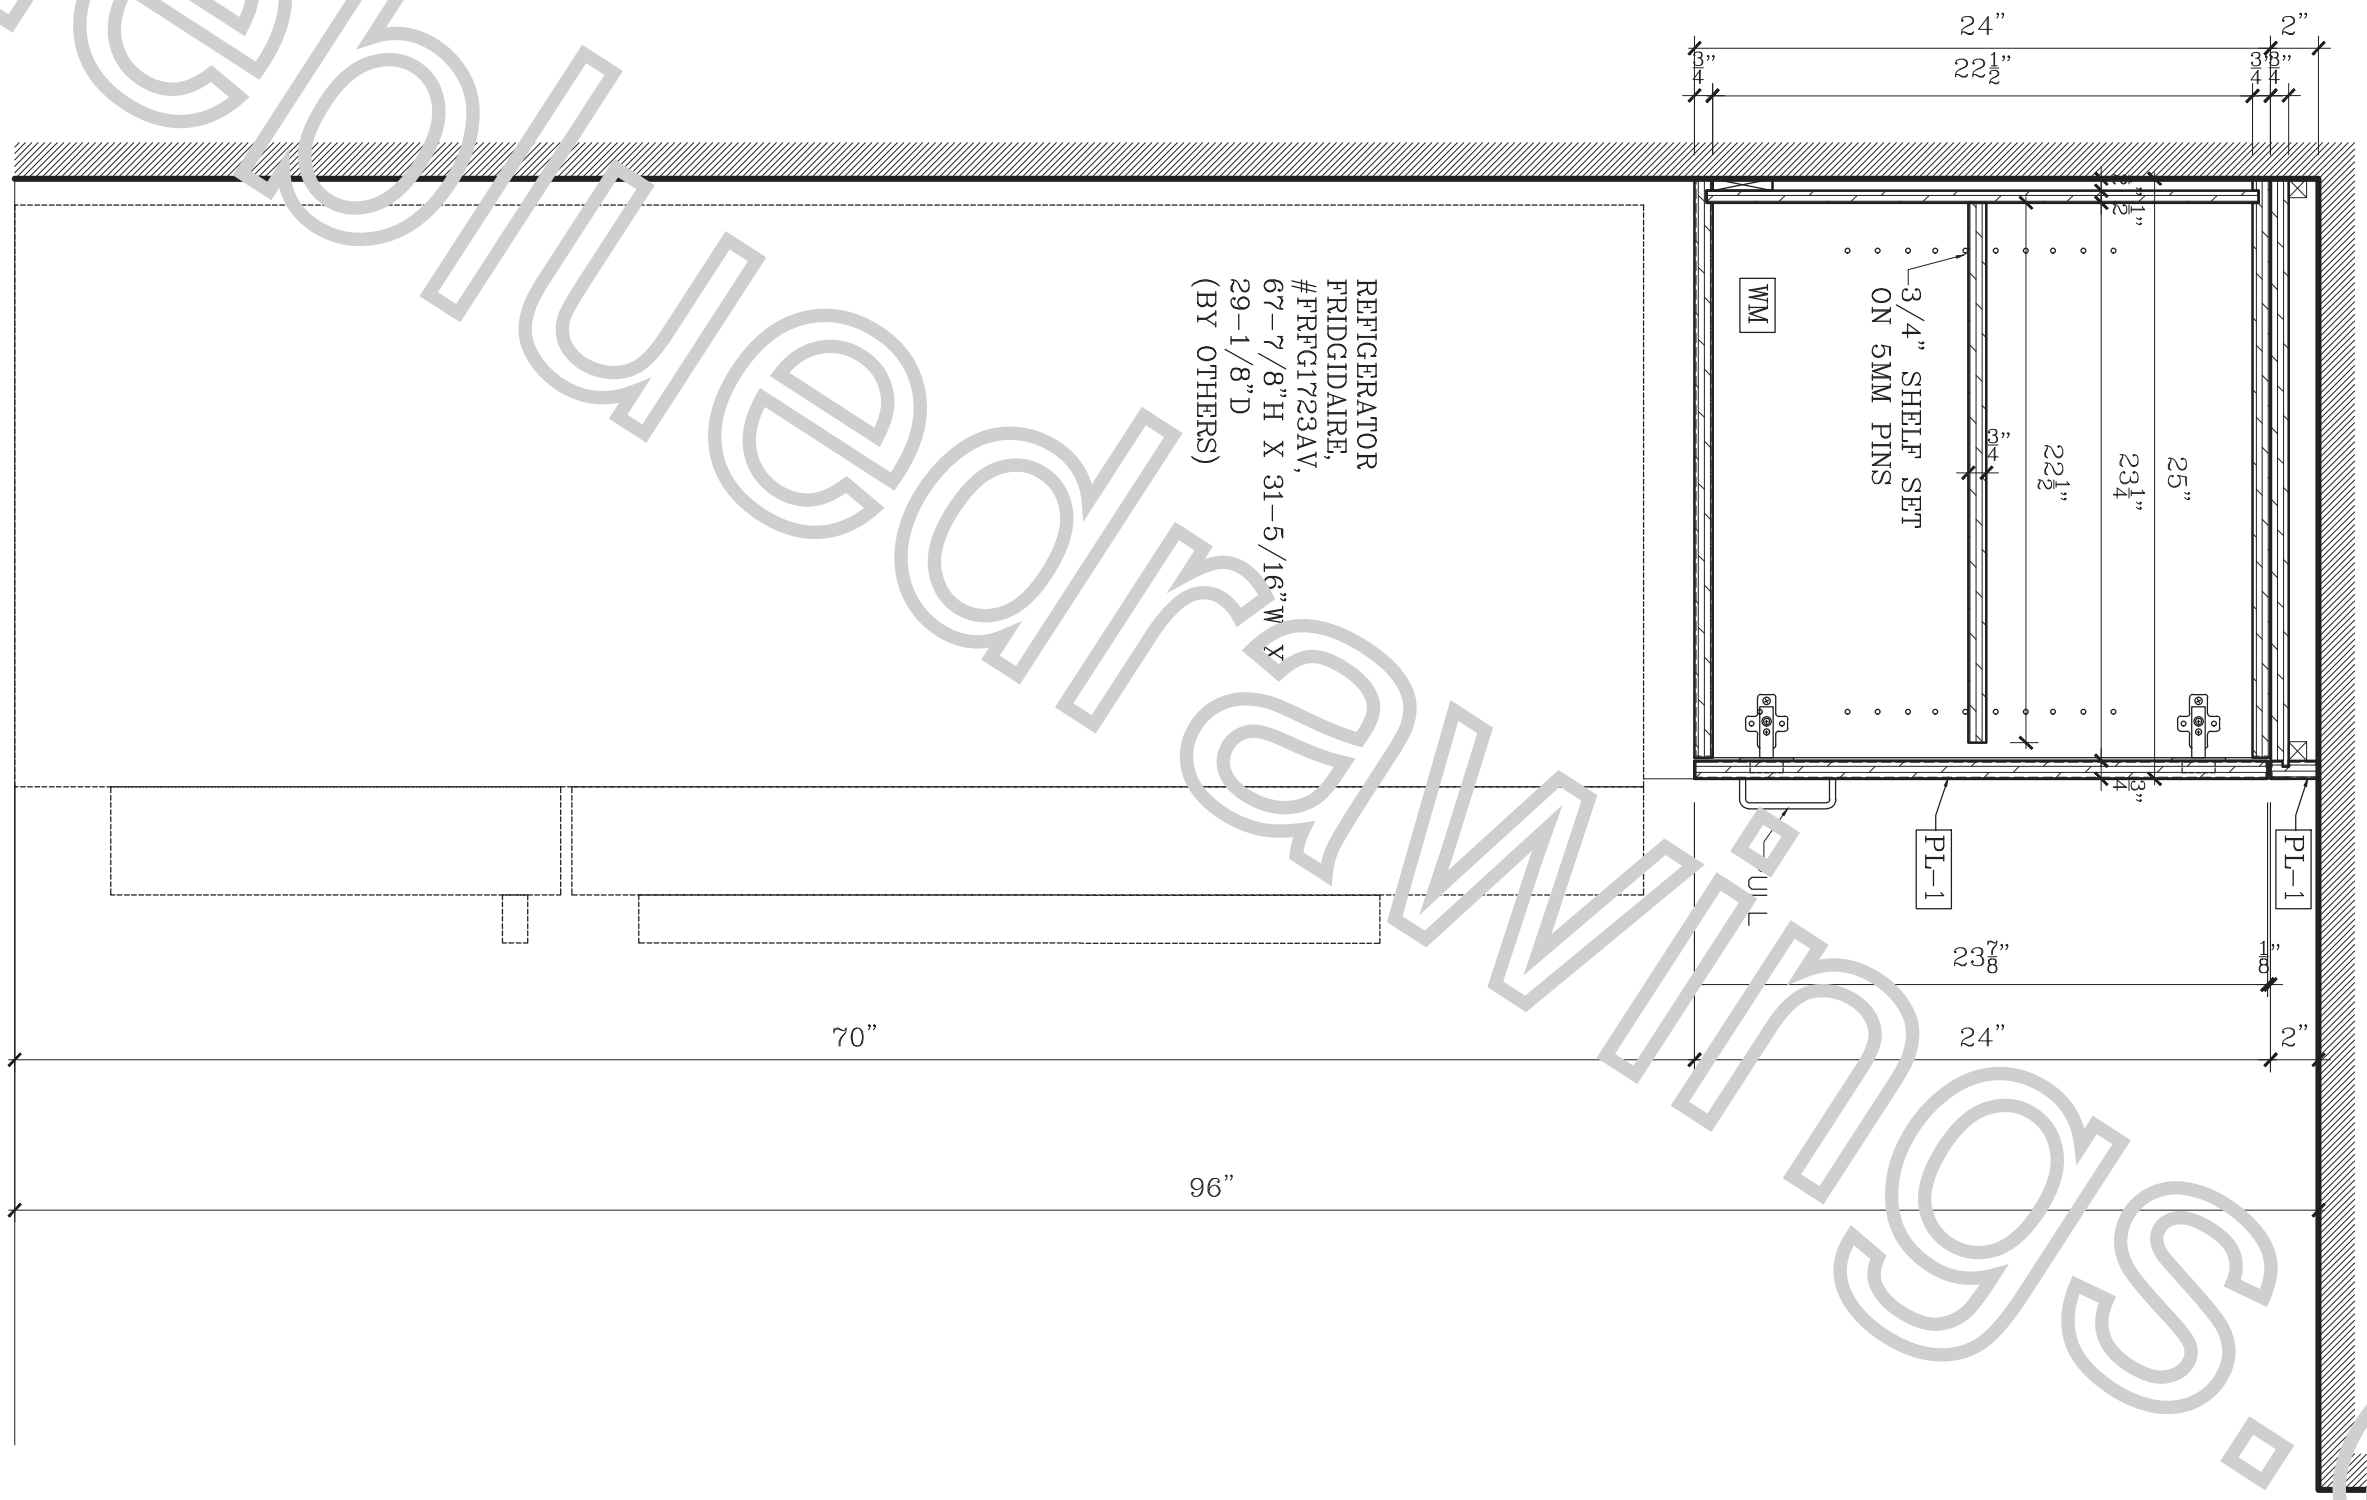

SPECIFICATIONS

FINISHES
 PL-1: PLASTIC LAMINATE, FENIX, BLU FES J0754, MATTE FINISCH
 PL-2: PLASTIC LAMINATE, BELLA LAMINATI, OREGON LEAF WOOD PW-6602, MULTI RIGHE
 WD-1: STAINED WOOD WALNUT TO MATCH SURFACING TAMBOR WALL PANELS SKU-383
 S-1: MANMADE QUARTZ SLABS, DEKTON, TRANCE ONIRIKA, POLISHED FINISH
 WM: WHITE MELAMINE

HARDWARE
 HINGES: CONCEALED SELF CLOSING
 SLIDING TRACKS: ACCURIDE MEDIUM DUTY FULL EXTENSION, SIDE MOUNTED
 PULLS: TBD

APPLIANCE & EXCLUSIONS
 APPLIANCES BY OTHERS
 PLUMBING FIXTURES BY OTHERS
 STONE BY OTHERS

APPROVED/NO CHANGES
 APPROVED/AS NOTED
 REVISE AS NOTED/RESUBMIT
 SIGNATURE _____ DATE _____

REVISIONS

Nr	DATE	DESCRIPTION	BY	OBS.

ONCE APPROVED, THIS DRAWING SUPERSEDES ALL PREVIOUS ARCHITECTURAL & SHOP DRAWINGS
 APPROVED BY: _____
 SIGNATURE _____ DATE _____


ABBREVIATIONS

AFF=Above Fin Floor	FE=Finished End
BSE=Base	FF=Face Frame
BOX=Back	FO=Finished Opening
CAB1=Cabinet	FP=Fixed Panel
CAS=Casing	IS=Inner Dimension
CO=Clear Opening	OJ=Outer Dimension
CTOP=Counter Top	PAN=Panel
DB=Drawer Box	RO=Rough Opening
DF=Drawer Face	PO=Pull Out Tray
WF=Verify in Field	REM=Removable Panel
DI=Field Dimension	SIF=Adj. Shelf

PROJECT: _____

DRAWING TITLE: Panty 17
 DRAWN BY: _____ SCALE: _____ DWG NO.: _____
 DATE: 11/07/20 AS NOTED _____

1 VERTICAL HORIZONTAL SECTION
Scale: 1-1/2"=1'

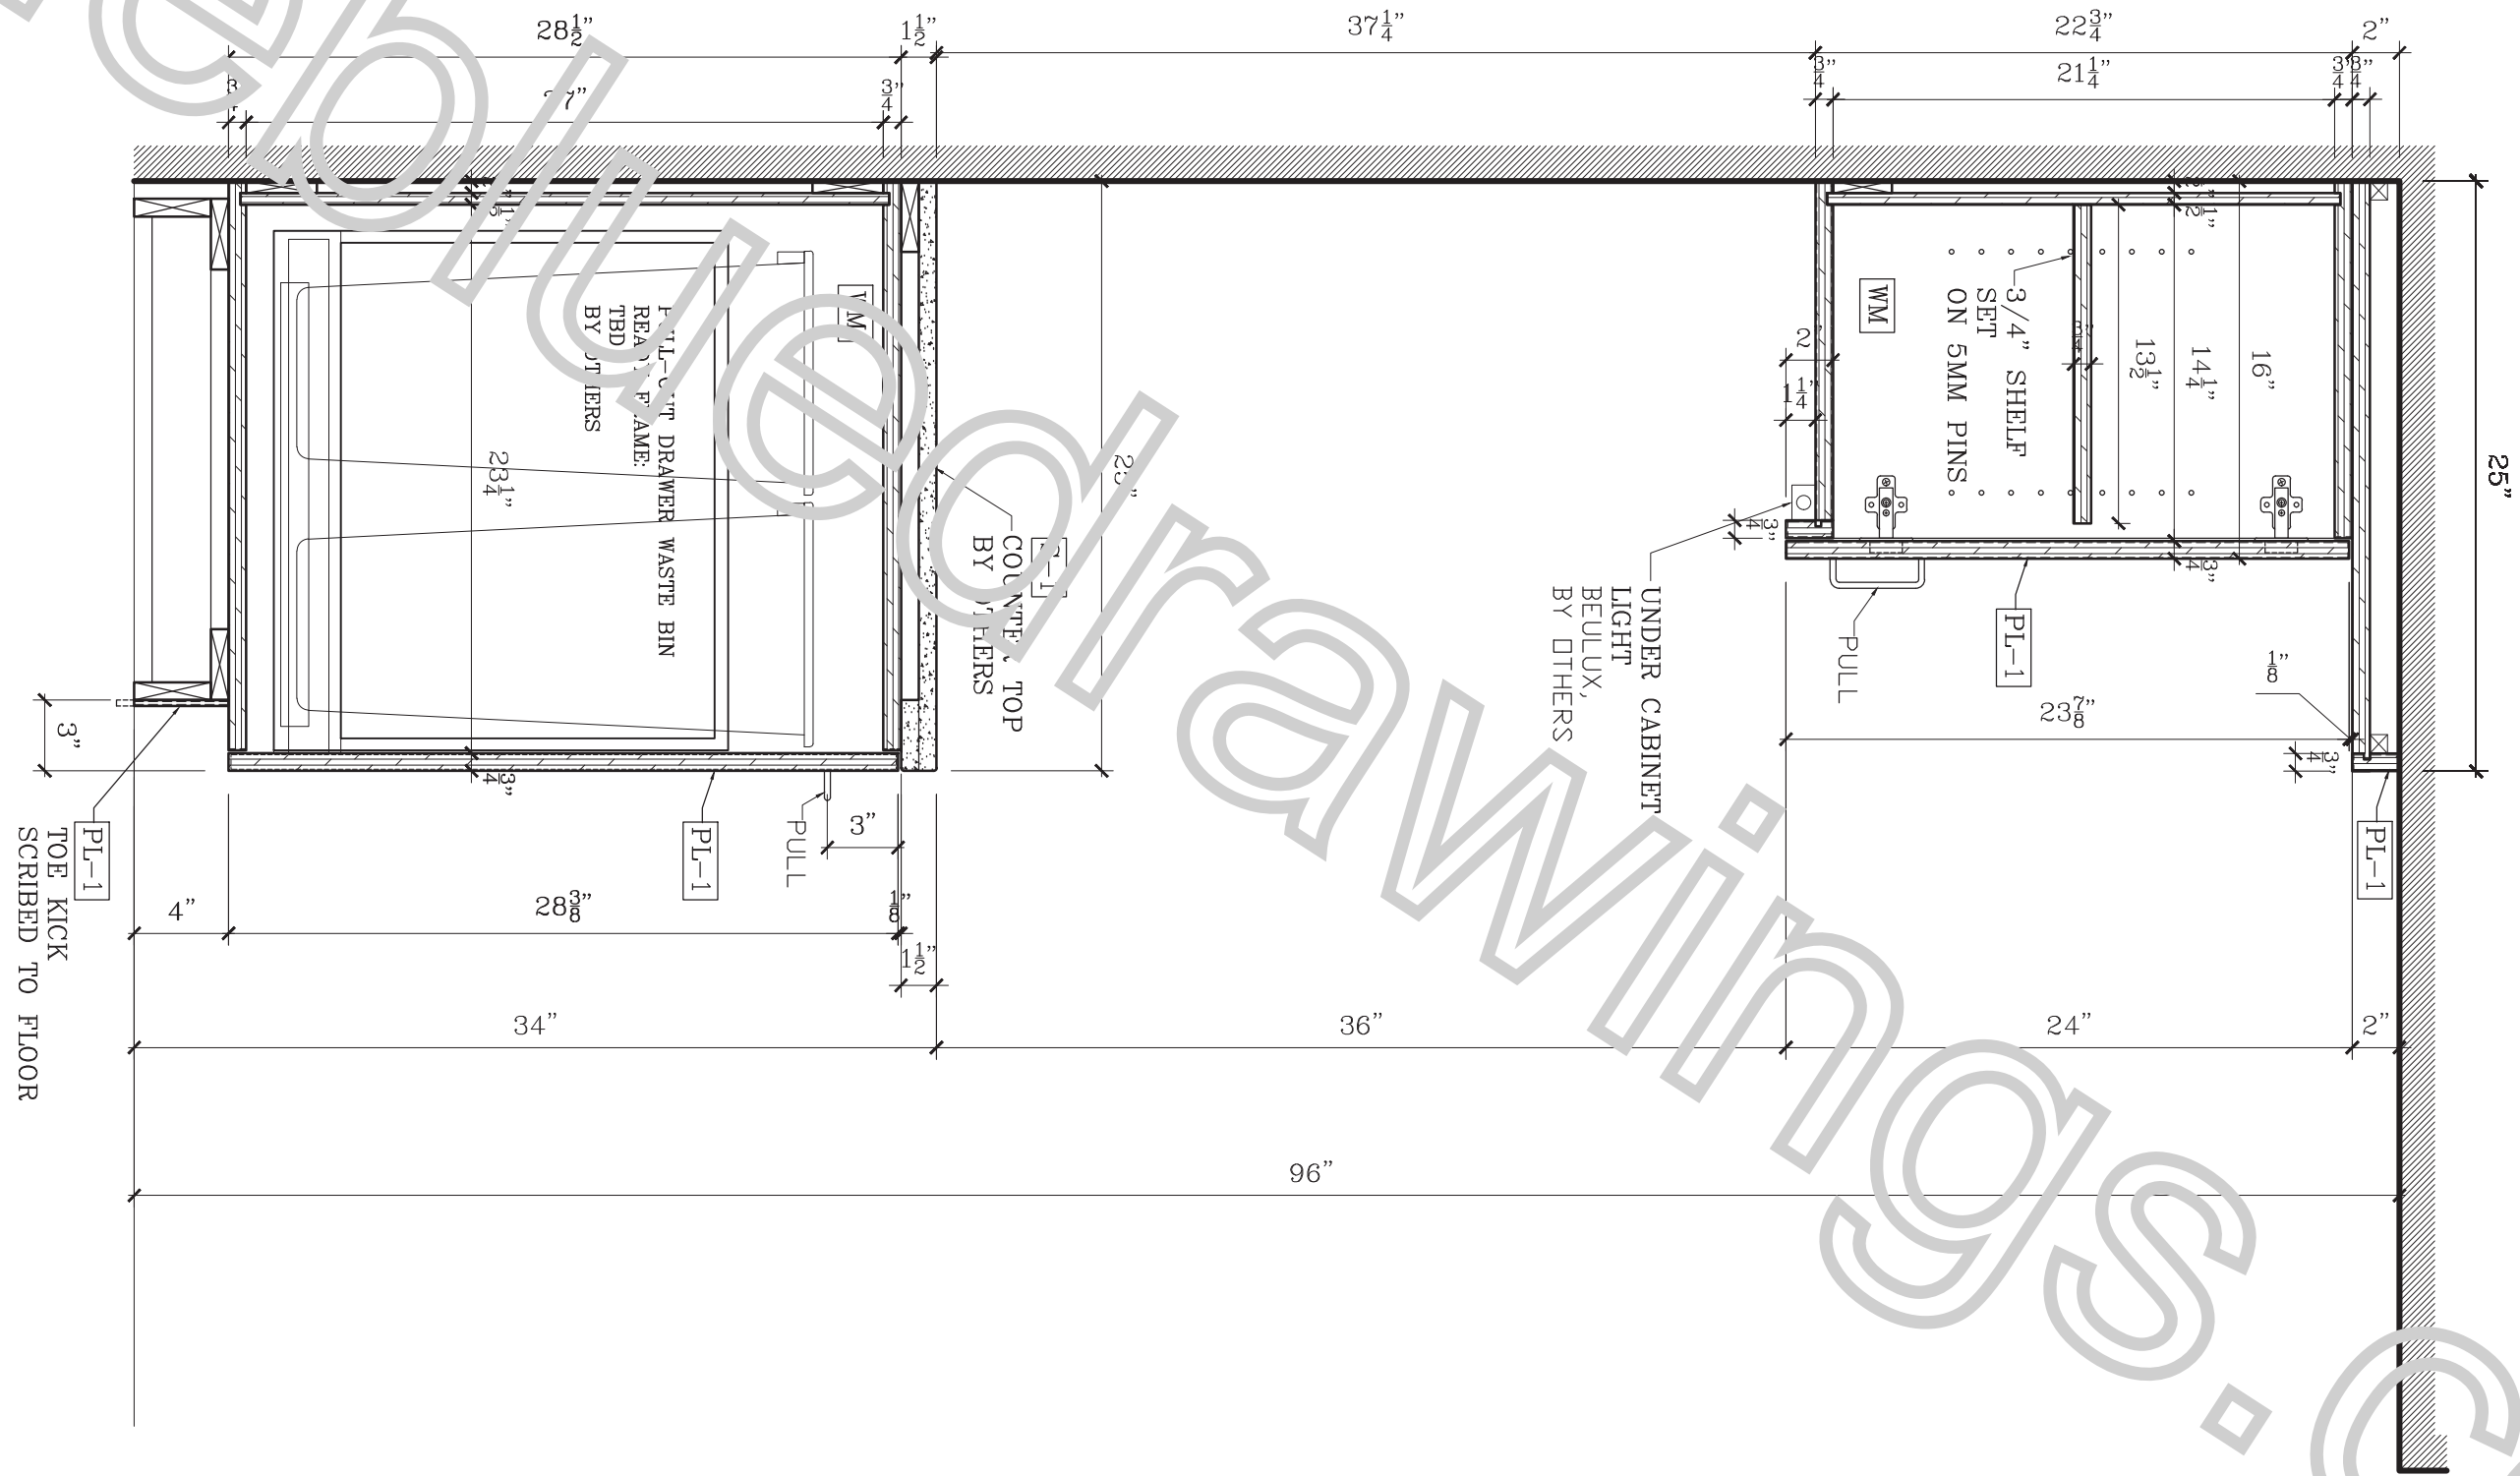


SPECIFICATIONS				
FINISHES				
PL-1: PLASTIC LAMINATE, FENIX, BLU FES J0754, MATTE FINISCH				
PL-2: PLASTIC LAMINATE, BELLA LAMINATI, OREGON LEAF WOOD PW-6002, MULTI RIGHE				
WD-1: STAINED WOOD WALNUT TO MATCH SURFACING TAMBOR WALL PANELS SKU-383				
S-1: MANMADE QUARTZ SLABS, DEKTON, TRANCE ONIRIKA, POLISHED FINISH				
WM: WHITE MELAMINE				
HARDWARE				
HINGES: CONCEALED SELF CLOSING				
SLIDING TRACKS: ACCURIDE MEDIUM DUTY FULL EXTENSION, SIDE MOUNTED				
PULLS: TBD				
APPLIANCE & EXCLUSIONS				
APPLIANCES BY OTHERS				
PLUMBING FIXTURES BY OTHERS				
STONE BY OTHERS				
APPROVED/NO CHANGES				
APPROVED/AS NOTED				
REVISE AS NOTED/RESUBMIT				
SIGNATURE _____		DATE _____		
REVISIONS				
Nr	DATE	DESCRIPTION	BY	OBS.
ONCE APPROVED, THIS DRAWING SUPERSEDES ALL PREVIOUS ARCHITECTURAL & SHOP DRAWINGS				
APPROVED BY: _____				
SIGNATURE _____		DATE _____		
ABBREVIATIONS				
AFF=Above Fin Floor	FE=Finished End			
BSE=Base	FF=Face Frame			
BOX=Back	FO=Finished Opening			
CAB=Cabinet	FP=Fixed Panel			
CAS=Casing	FD=Field Dimension			
CL=Clear Opening	OJ=Outer Dimension			
CTOP=Counter Top	PAN=Panel			
DB=Drawer Box	RO=Rough Opening			
DF=Drawer Face	PO=Pull Out Tray			
WF=Verify in Field	REM=Removable Panel			
FD=Field Dimension	SIF=Add Shelf			
PROJECT: _____				
WOODWORK, INC.				
DRAWING TITLE: Panty 17				
OWN BY: _____	SCALE: AS NOTED	DWG NO.: 315		
DATE: 11/07/2				

1

VERTICAL HORIZONTAL SECTION

Scale: 1-1/2"=1'

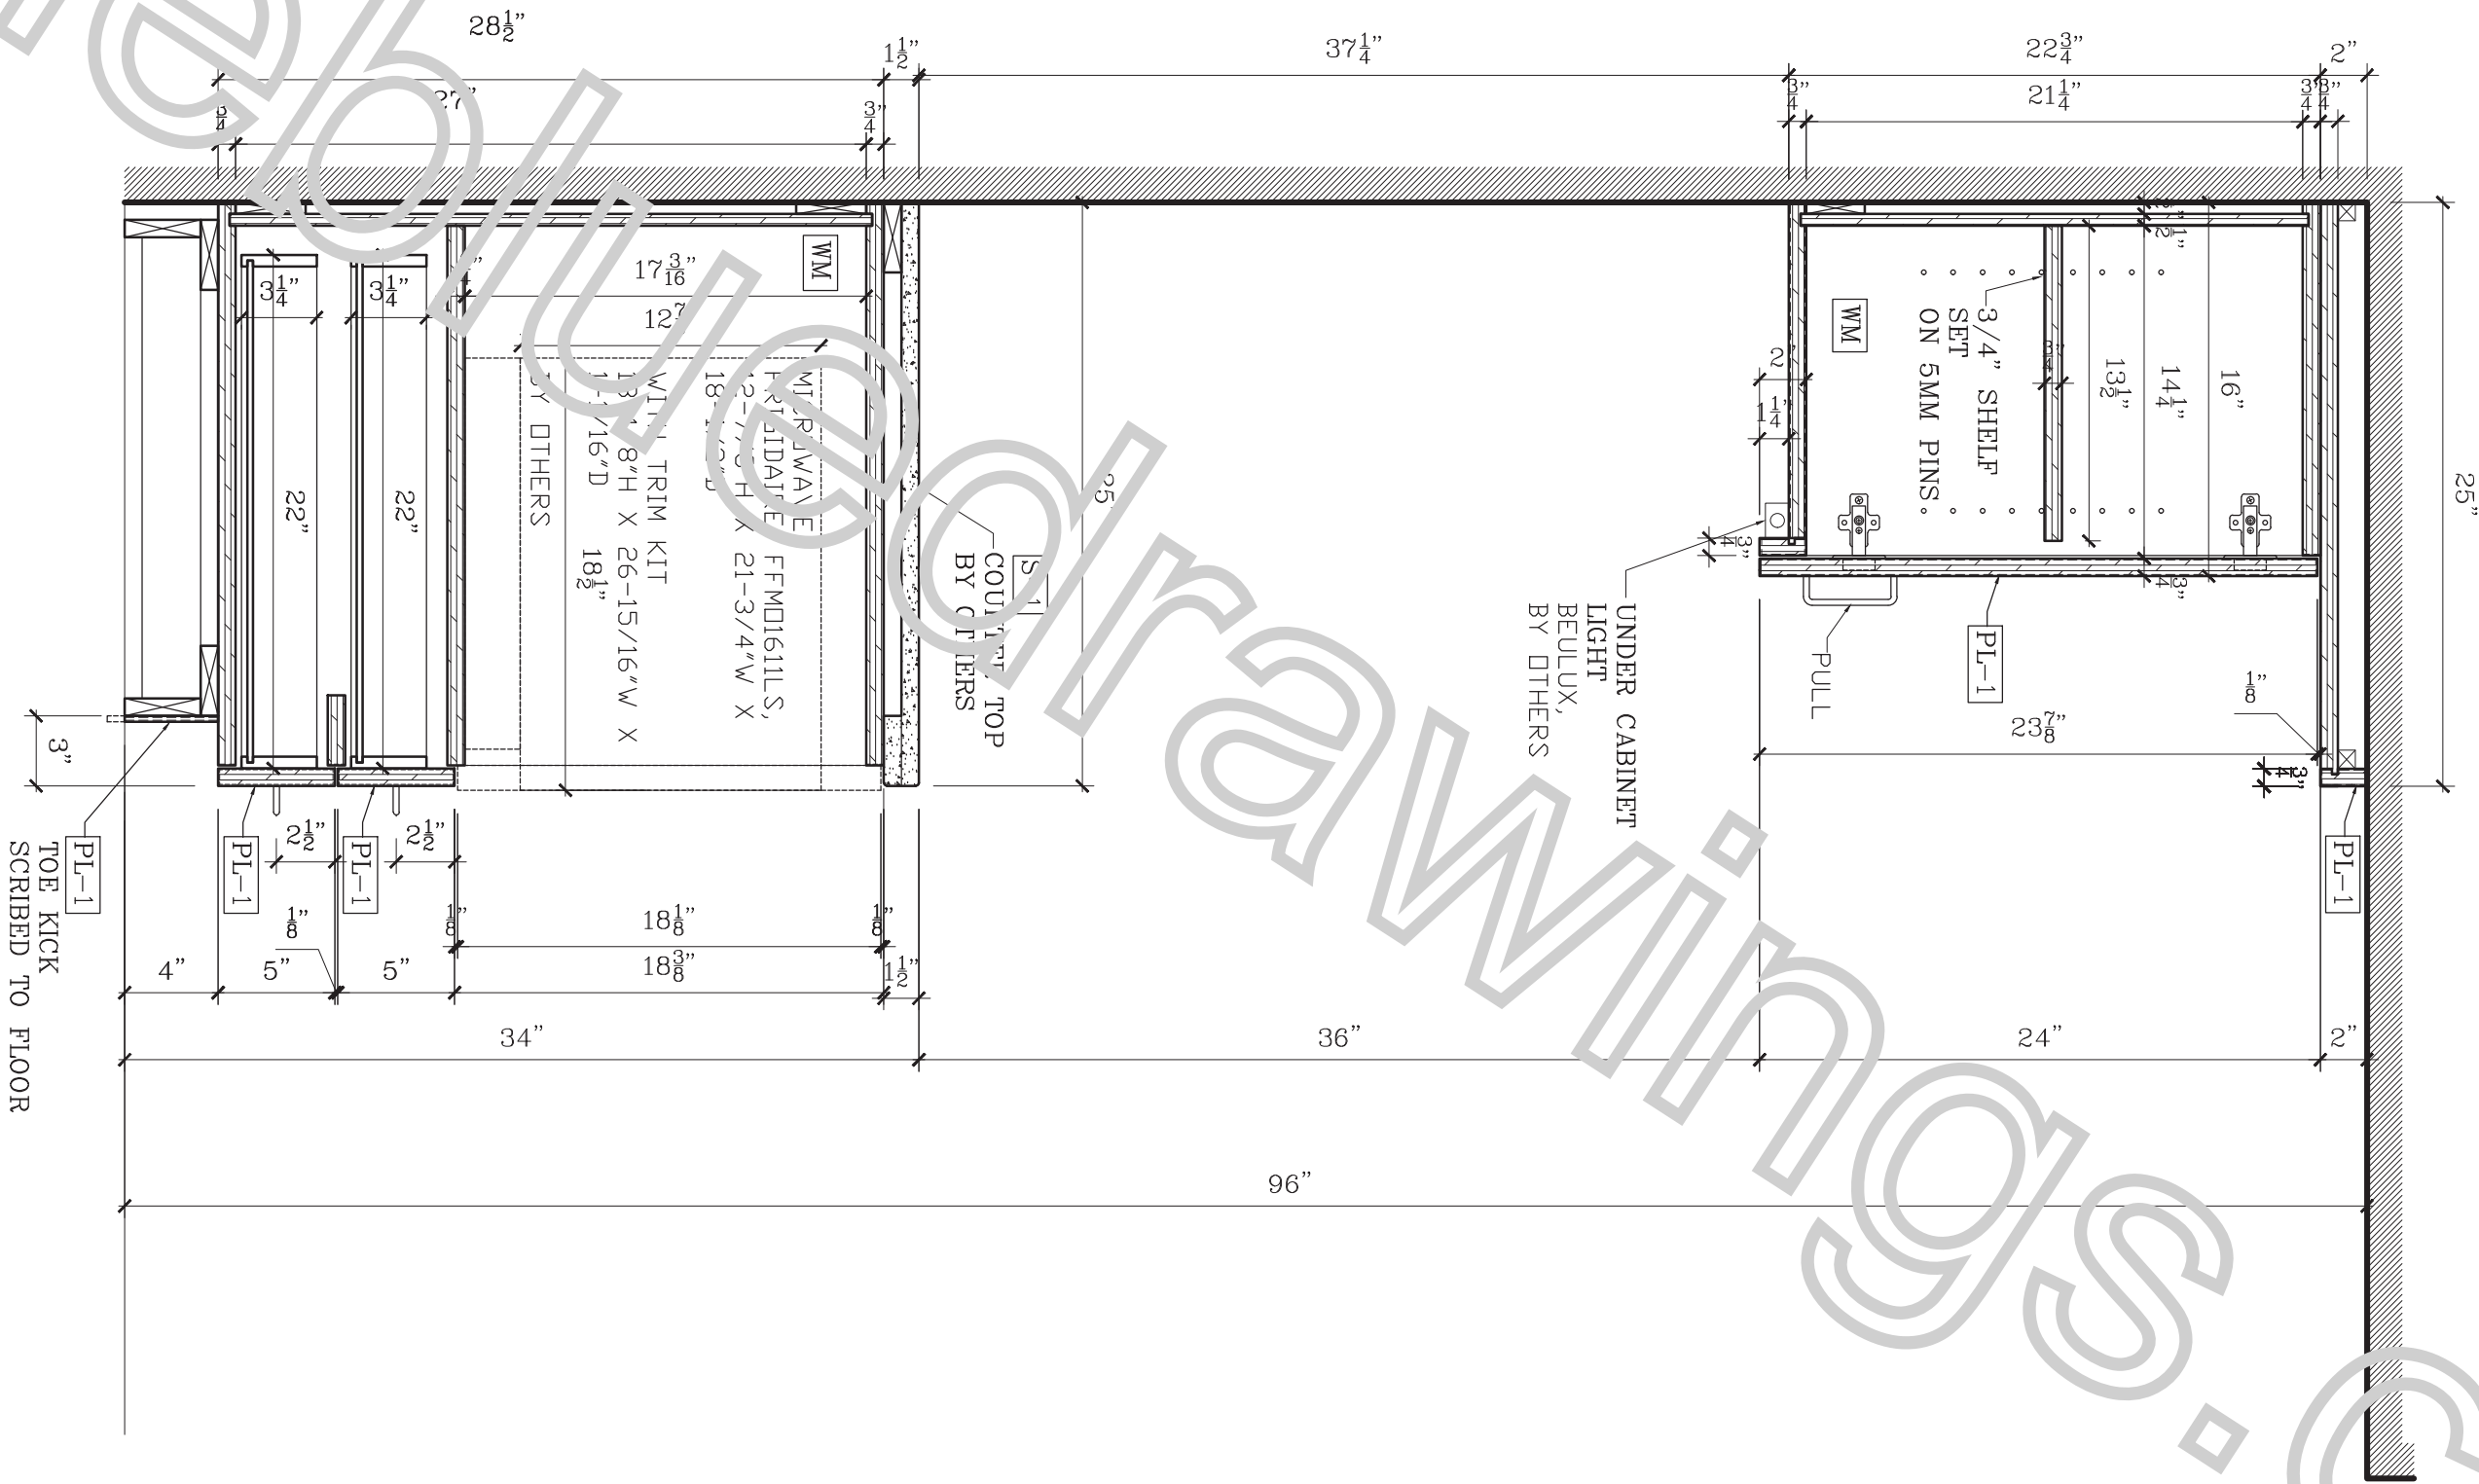

SPECIFICATIONS

FINISHES

PL-1: PLASTIC LAMINATE, FENIX, BLU FES J0754, MATTE FINISCH
 PL-2: PLASTIC LAMINATE, BELLA LAMINATI, OREGON LEAF WOOD PW-6602, MULTI RIGHE
 WD-1: STAINED WOOD WALNUT TO MATCH SURFACING TAMBOR WALL PANELS SKU-383

S-1: MANMADE QUARTZ SLABS, DEKTON, TRANCE ONIRIKA, POLISHED FINISH

WM: WHITE MELAMINE

HARDWARE

HINGES: CONCEALED SELF CLOSING

SLIDING TRACKS: ACCURIDE MEDIUM DUTY FULL EXTENSION, SIDE MOUNTED

PULLS: TBD

APPLIANCE & EXCLUSIONS

APPLIANCES BY OTHERS
PLUMBING FIXTURES BY OTHERS
STONE BY OTHERS

APPROVED/NO CHANGES
 APPROVED/AS NOTED
 REVISE AS NOTED/RESUBMIT

SIGNATURE _____ DATE _____

REVISIONS

Nr	DATE	DESCRIPTION	BY	OBS.

ONCE APPROVED, THIS DRAWING SUPERSEDES ALL PREVIOUS ARCHITECTURAL & SHOP DRAWINGS

APPROVED BY: _____

SIGNATURE _____ DATE _____

ABBREVIATIONS

AFF=Above Fin Floor	FE=Finished End
BSE=Base	FF=Face Frame
BOX=Back	FO=Finished Opening
CAB=Cabinet	FP=Fixed Panel
CAS=Casing	FD=Face Dimension
CL=Clear Opening	OD=Outer Dimension
CTOP=Counter Top	PNL=Panel
DB=Drawer Box	RO=Rough Opening
DF=Drawer Face	PO=Pull Out Tray
WF=Verify In Field	REM=Removable Panel
FD=Field Dimension	SH=Shelf

PROJECT: [REDACTED]


DRAWING TITLE: Panty 17

DATE: 11/07/2

SCALE: AS NOTED

DWG NO.: 31.6

1 VERTICAL HORIZONTAL SECTION
Scale: 1-1/2"=1'

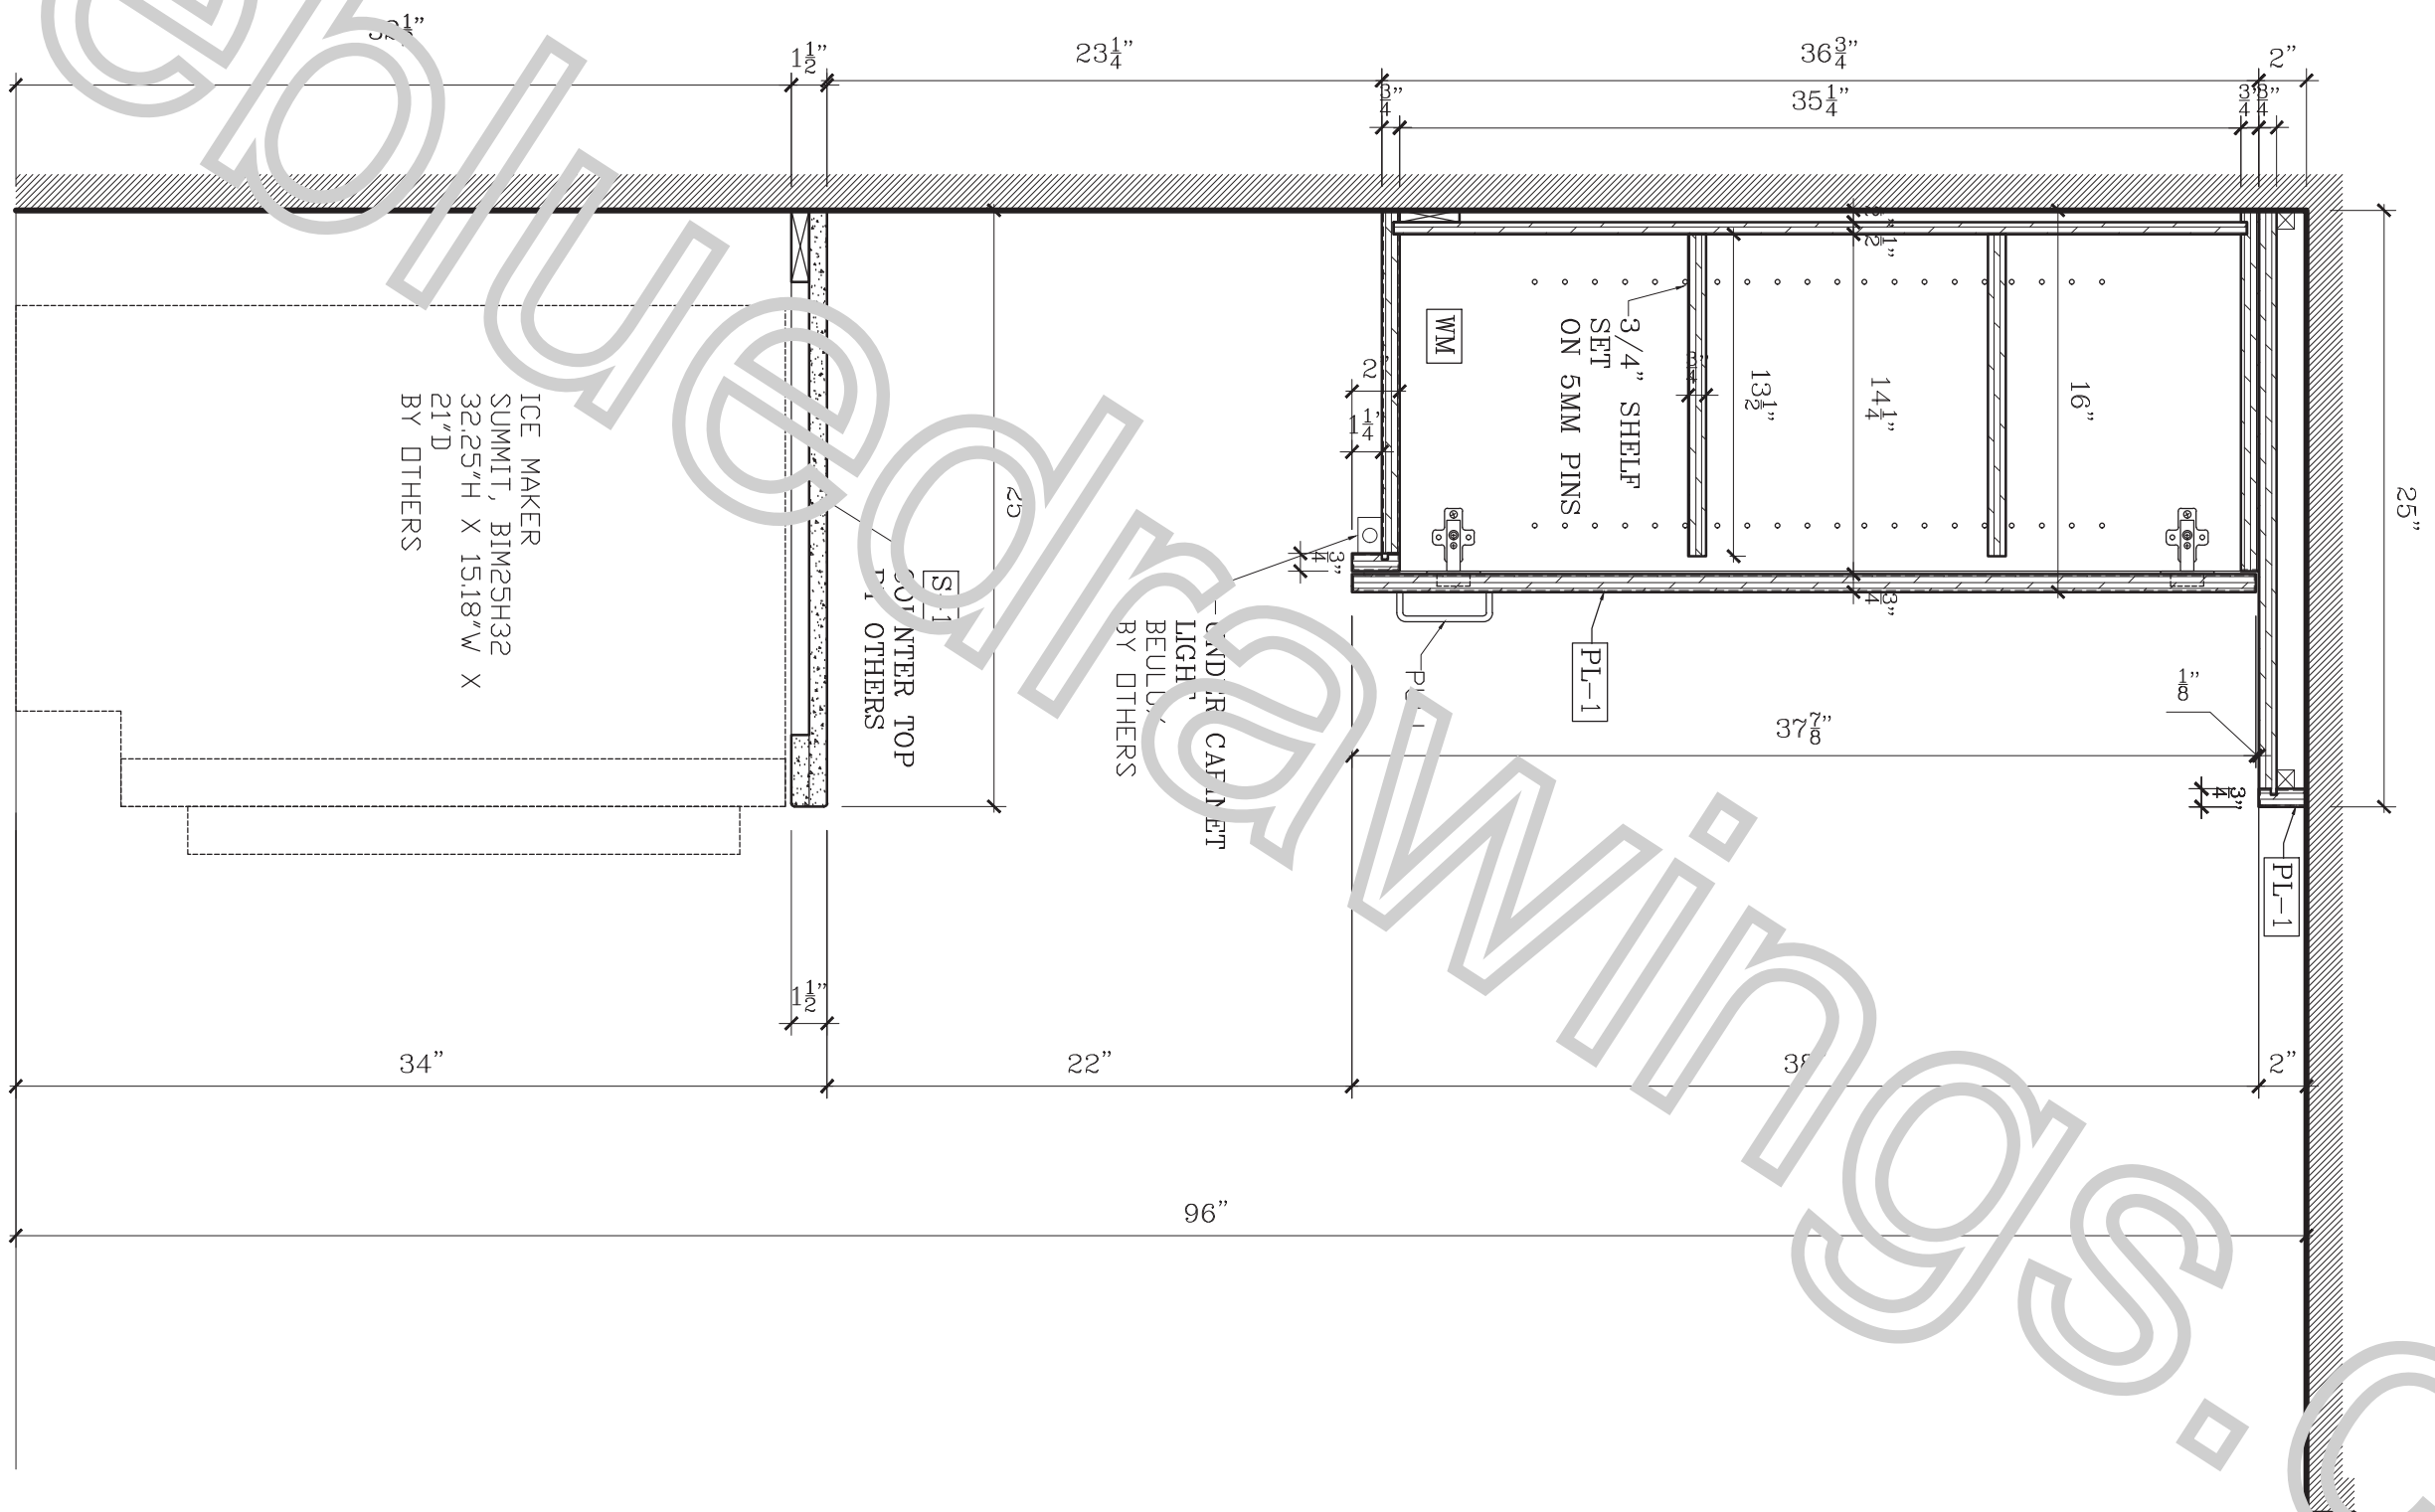

ICE MAKER
SUMMIT, BIM25H32
32.25\"/>

COUNTER TOP
BY OTHERS

LAND J.R. CAFE
LIGHT
BEULON
BY OTHERS

3/4\"/>

SPECIFICATIONS

FINISHES
 PL-1: PLASTIC LAMINATE, FENIX, BLU FES J0754, MATTE FINISCH
 PL-2: PLASTIC LAMINATE, BELLA LAMINATI, OREGON LEAF WOOD PW-6602, MULTI RIGHE
 WD-1: STAINED WOOD WALNUT TO MATCH SURFACING TAMBOR WALL PANELS SKU-383
 S-1: MANMADE QUARTZ SLABS, DEKTON, TRANCE ONIRIKA, POLISHED FINISH
 WM: WHITE MELAMINE

HARDWARE
 HINGES: CONCEALED SELF CLOSING
 SLIDING TRACKS: ACCURIDE MEDIUM DUTY FULL EXTENSION, SIDE MOUNTED
 PULLS: TBD

APPLIANCE & EXCLUSIONS
 APPLIANCES BY OTHERS
 PLUMBING FIXTURES BY OTHERS
 STONE BY OTHERS

APPROVED/NO CHANGES
 APPROVED/AS NOTED
 REVISE AS NOTED/RESUBMIT

SIGNATURE _____ DATE _____

REVISIONS

Nr	DATE	DESCRIPTION	BY	OBS.

ONCE APPROVED, THIS DRAWING SUPERSEDES ALL PREVIOUS ARCHITECTURAL & SHOP DRAWINGS

APPROVED BY: _____

SIGNATURE _____ DATE _____

ABBREVIATIONS

AFF=Above Fin Floor	FE=Finished End
BSE=Base	FF=Face Frame
BCK=Back	FO=Finished Opening
CAB1=Cabinet	FP=Fixed Panel
CAS=Casing	IS=Inner Dimension
CL=Clear Opening	OJ=Outer Dimension
CTOP=Counter Top	PAN=Panel
DB=Drawer Box	RO=Rough Opening
DF=Drawer Face	POI=Pull Out Tray
WF=Verify in Field	REM=Removable Panel
FD=Field Dimension	SIF=Add Shelf

PROJECT: _____

D _____

A _____

F _____

C _____

T _____

DRAWING TITLE: Panty 17


DWN BY: _____ SCALE: AS NOTED DWG NO.: _____

DATE: 11/07/20 _____

1

VERTICAL HORIZONTAL SECTION

Scale: 1-1/2"=1'

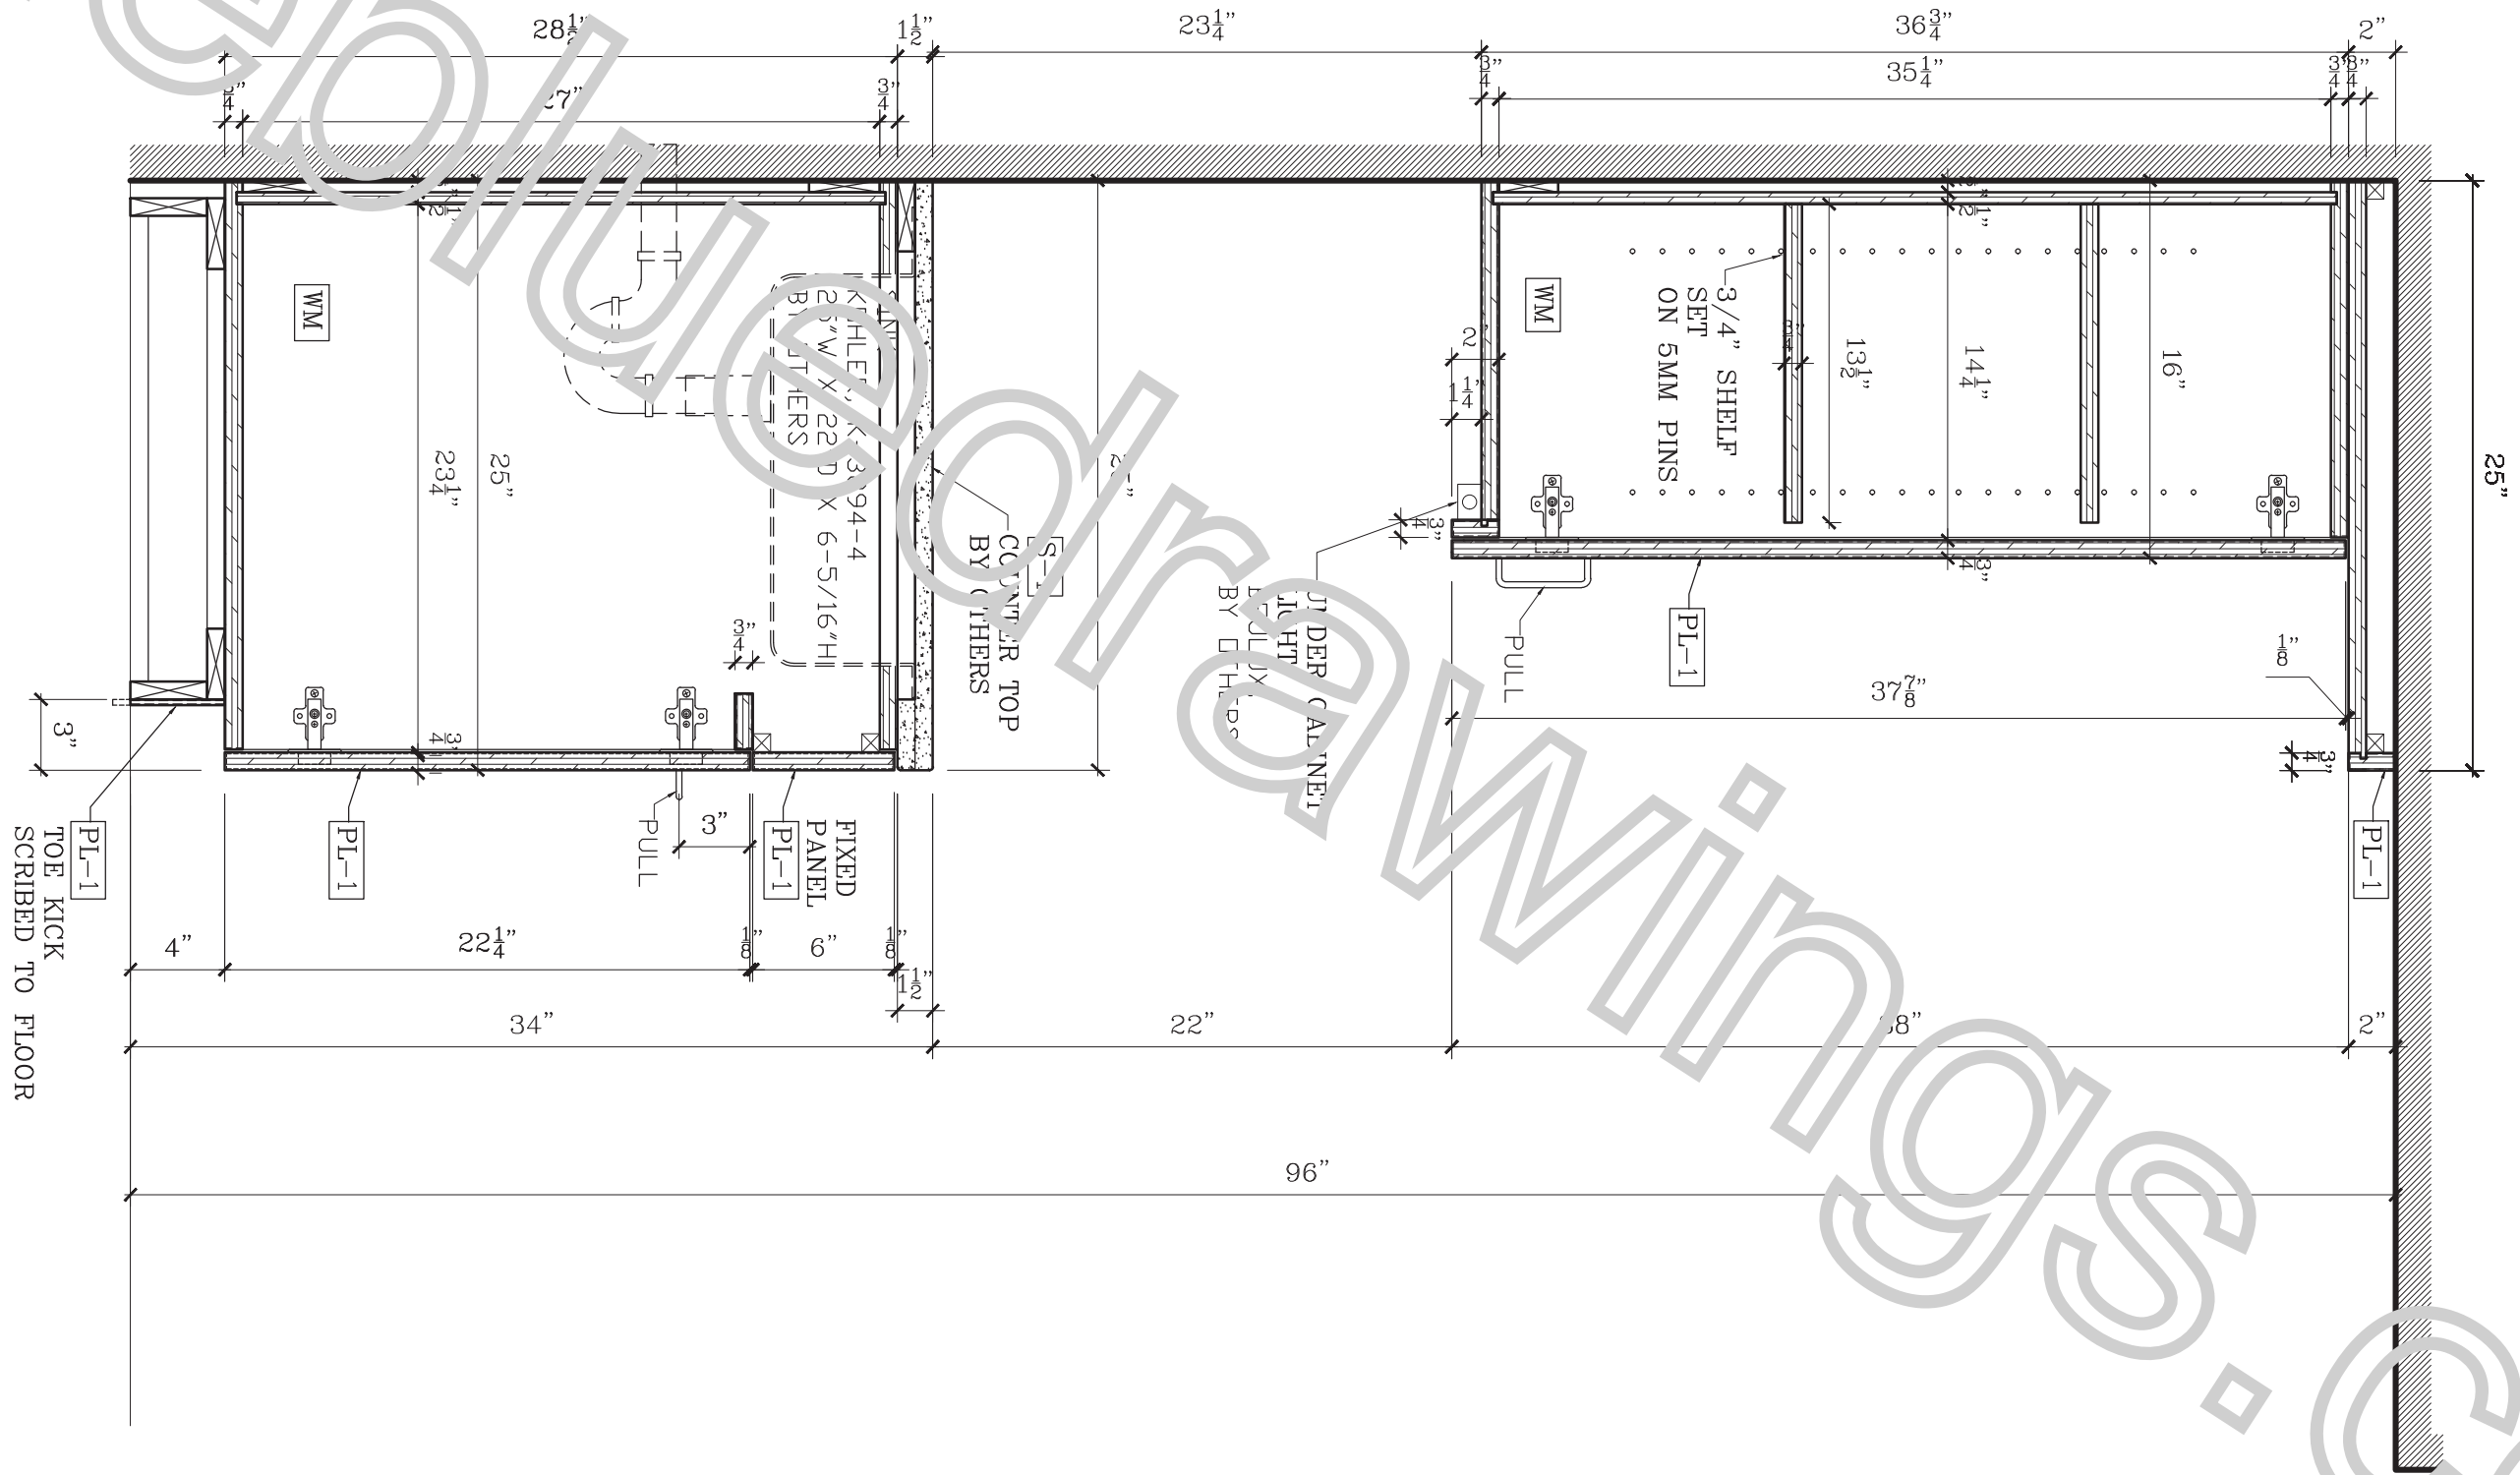

SPECIFICATIONS

FINISHES
 PL-1: PLASTIC LAMINATE, FENIX, BLU FES J0754, MATTE FINISCH
 PL-2: PLASTIC LAMINATE, BELLA LAMINATI, OREGON LEAF WOOD PW-6602, MULTI RIGHE
 WD-1: STAINED WOOD WALNUT TO MATCH SURFACING TAMBOR WALL PANELS SKU-383
 S-1: MANMADE QUARTZ SLABS, DEKTON, TRANCE ONIRIKA, POLISHED FINISH
 WM: WHITE MELAMINE

HARDWARE
 HINGES: CONCEALED SELF CLOSING
 SLIDING TRACKS: ACCURIDE MEDIUM DUTY FULL EXTENSION, SIDE MOUNTED
 PULLS: TBD

APPLIANCE & EXCLUSIONS
 APPLIANCES BY OTHERS
 PLUMBING FIXTURES BY OTHERS
 STONE BY OTHERS

APPROVED/NO CHANGES
 APPROVED/AS NOTED
 REVISE AS NOTED/RESUBMIT
 SIGNATURE _____ DATE _____

REVISIONS

Nr	DATE	DESCRIPTION	BY	OBS.

ONCE APPROVED, THIS DRAWING SUPERSEDES ALL PREVIOUS ARCHITECTURAL & SHOP DRAWINGS
 APPROVED BY:
 SIGNATURE _____ DATE _____


ABBREVIATIONS

AFF=Above Fin Floor	FE=Finished End
BSE=Base	FF=Face Frame
BCK=Back	FO=Finished Opening
CABT=Cabinet	FP=Fixed Panel
CAS=Casing	FD=Face Dimension
CL=Clear Opening	OU=Outer Dimension
CTOP=Counter Top	PAN=Panel
DB=Drawer Box	RO=Rough Opening
DF=Drawer Face	PO=Pull Out Tray
WF=Verify in Field	REM=Removable Panel
FD=Field Dimension	SH=Shelf

PROJECT:
 D [Redacted Box]

DRAWING TITLE: Panty 17
 DRAWN BY: [Redacted] SCALE: AS NOTED DWG NO.: 018
 DATE: 11/07/2

1 VERTICAL HORIZONTAL SECTION
Scale: 1-1/2"=1'

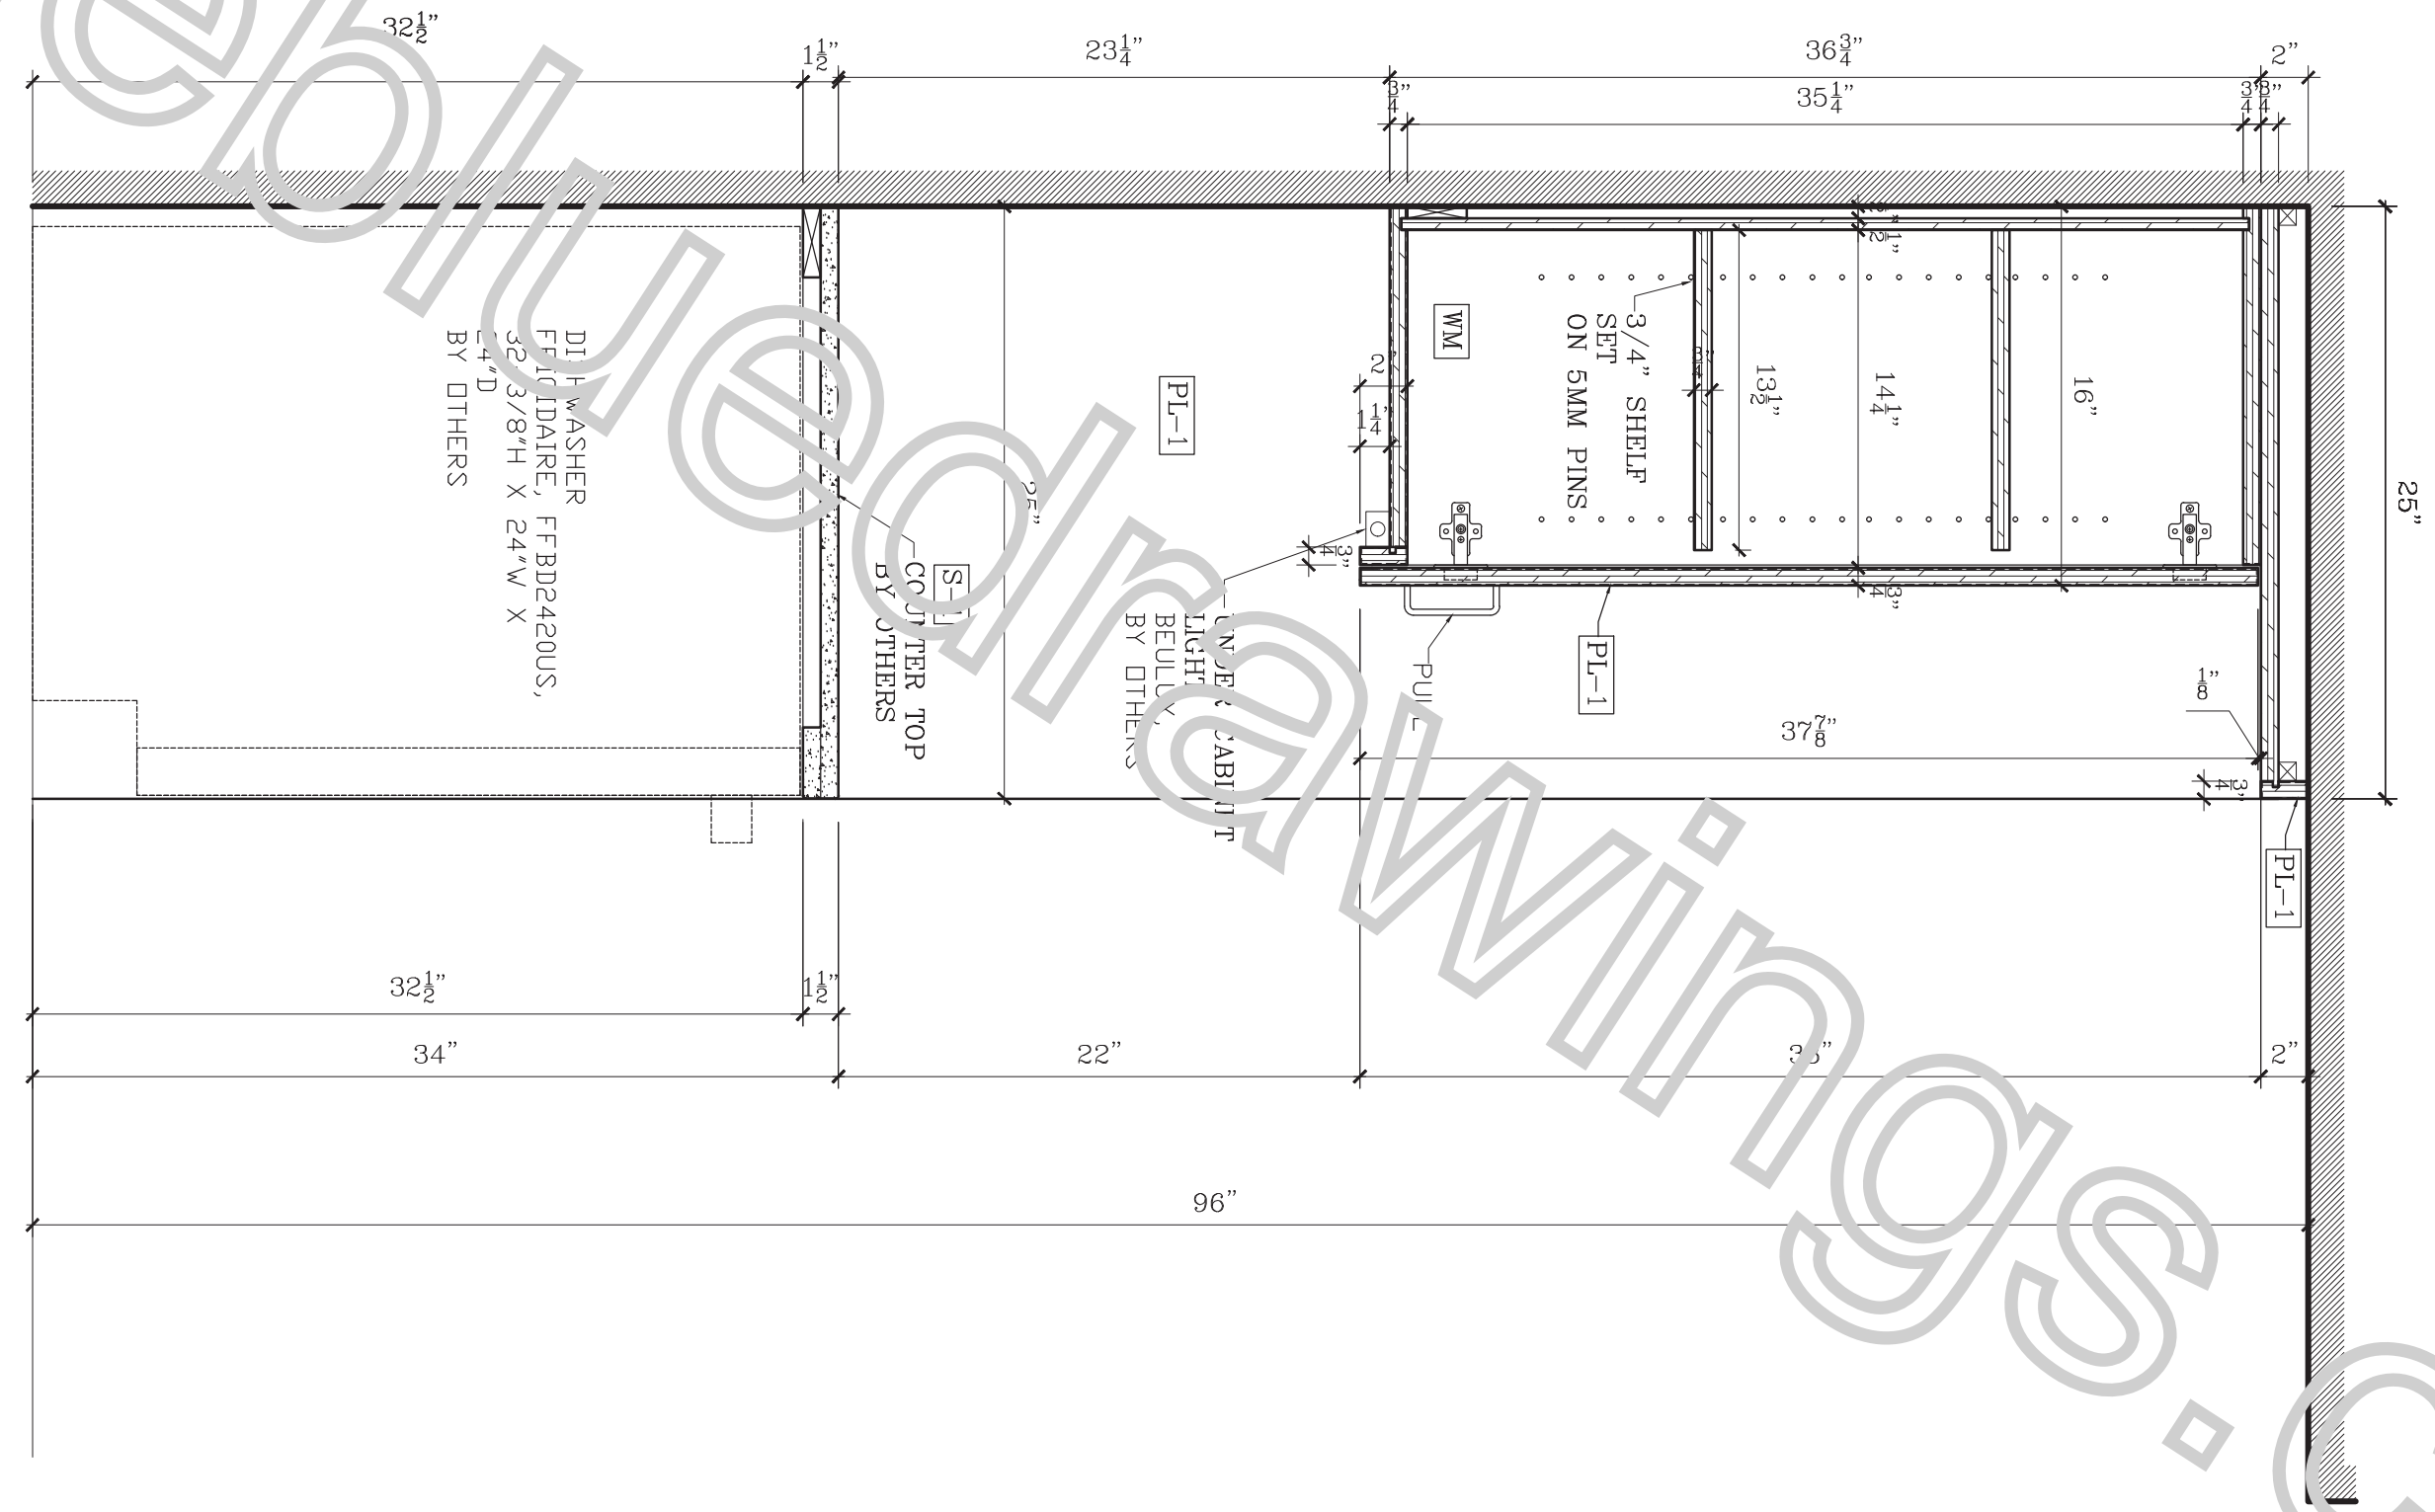

SPECIFICATIONS

FINISHES
 PL-1: PLASTIC LAMINATE, FENIX, BLU FES J0754, MATTE FINISCH
 PL-2: PLASTIC LAMINATE, BELLA LAMINATI, OREGON LEAF WOOD PW-6002, MULTI RIGHE
 WD-1: STAINED WOOD WALNUT TO MATCH SURFACING TAMBOR WALL PANELS SKU-383

S-1: MANMADE QUARTZ SLABS, DEKTON, TRANCE ONIRIKA, POLISHED FINISH

WM: WHITE MELAMINE

HARDWARE
HINGES: CONCEALED SELF CLOSING
SLIDING TRACKS: ACCURIDE MEDIUM DUTY FULL EXTENSION, SIDE MOUNTED
PULLS: TBD

APPLIANCE & EXCLUSIONS
APPLIANCES BY OTHERS
PLUMBING FIXTURES BY OTHERS
STONE BY OTHERS

APPROVED/NO CHANGES
 APPROVED/AS NOTED
 REVISE AS NOTED/RESUBMIT

SIGNATURE _____ DATE _____

REVISIONS

Nr	DATE	DESCRIPTION	BY	OBS.

ONCE APPROVED, THIS DRAWING SUPERSEDES ALL PREVIOUS ARCHITECTURAL & SHOP DRAWINGS

APPROVED BY: _____

SIGNATURE _____ DATE _____

ABBREVIATIONS

AFF=Above Fin Floor	FE=Finished End
BSE=Base	FF=Face Frame
BCK=Back	FO=Finished Opening
CABT=Cabinet	FP=Fixed Panel
CAS=Casing	FD=Fixed Dimension
CO=Clear Opening	OJ=Outer Dimension
CTOP=Counter Top	PNL=Panel
DB=Drawer Box	RO=Rough Opening
DF=Drawer Face	POI=Pull Out Tray
WF=Verify in Field	REM=Removable Panel
FD=Field Dimension	SH=Shelf

PROJECT: _____

DRAWING TITLE: Panty 17

OWN BY: _____	SCALE: AS NOTED	DWG NO.: 319
DATE: 11/07/2		